

NOTES

- LIGHTING BY ORSMAN DESIGN, INC. (ODI)
- FIXTURE GROUPING - TYPICAL
- FIXTURE GROUPING - PATH
- FIXTURE GROUPING - REMOTE DRIVER

LIGHT FIXTURE LEGEND

SYMBOL	TYPE	DESCRIPTION
▲	A	UPLIGHT, ADJUSTABLE HEIGHT
→	B	DOWN LIGHT, TREE MOUNTED MR 16
└	C	PATH LIGHT, "L" STYLE
⊗	D	WELL LIGHT
⊙	E	PATH LIGHT, CIRCULAR STYLE
▲	F	STAFF LIGHT
▲	G	STEP LIGHT, IN-WALL
□□□□	H	LINEAR LED, EXTERIOR RATED
◆◆◆◆	J	STRING LIGHTS
⊞		TRANSFORMER
⊙		LINE VOLTAGE J BOX
⊙		LOW VOLTAGE J BOX
⊙		SPARE FEED
↔		PVC SLEEVE BY OTHERS

DRAWING REVISIONS

NO.	DATE	DESCRIPTION
1	04.27.2021	S.D.

PRIVATE RESIDENCE
59 TWEED BLVD
NYACK, NY
LANDSCAPE LIGHTING DESIGN

INDEX TO DRAWINGS

- C-0.0 COVER SHEET
- LL-1.0 LANDSCAPE LIGHTING PLAN
- LC-1.0 LANDSCAPE LIGHTING IMAGERY
- LC-1.1 LANDSCAPE LIGHTING IMAGERY
- LC-1.2 LANDSCAPE LIGHT FIXTURE IMAGERY

SCHEMATIC DESIGN
NOT FOR CONSTRUCTION

PROJECT	PRIVATE RESIDENCE 59 TWEED BLVD NYACK, NY
DWG TITLE	COVER SHEET
DATE	04.26.2021
SCALE	
SHEET NO.	C-0.0

NOTES

- LIGHTING BY ORSMAN DESIGN, INC. (ODI)
- FIXTURE GROUPING - TYPICAL
- FIXTURE GROUPING - PATH
- FIXTURE GROUPING - REMOTE DRIVER

LIGHT FIXTURE LEGEND

SYMBOL	TYPE	DESCRIPTION
▲	A	UPLIGHT, ADJUSTABLE HEIGHT
▼	B	DOWN LIGHT, TREE MOUNTED MR 16
└	C	PATH LIGHT, "L" STYLE
⊗	D	WELL LIGHT
⊙	E	PATH LIGHT, CIRCULAR STYLE
▲	F	STAFF LIGHT
▲	G	STEP LIGHT, IN-WALL
▬	H	LINEAR LED, EXTERIOR RATED
◆◆◆◆	J	STRING LIGHTS
⊕		TRANSFORMER
⊖		LINE VOLTAGE J BOX
⊗		LOW VOLTAGE J BOX
⊙		SPARE FEED
⊖		PVC SLEEVE BY OTHERS


DRAWING REVISIONS

I	04.27.2021 - S.D.
---	-------------------

PROJECT	PRIVATE RESIDENCE 59 TWEED BLVD NYACK, NY
DWG TITLE	LANDSCAPE LIGHTING PLAN
DATE	04.26.2021
SCALE	3/32" = 1'-0"
SHEET NO.	LL-1.0

SCHEMATIC DESIGN
NOT FOR CONSTRUCTION

LANDSCAPE LIGHTING PLAN
3/32" = 1'-0"

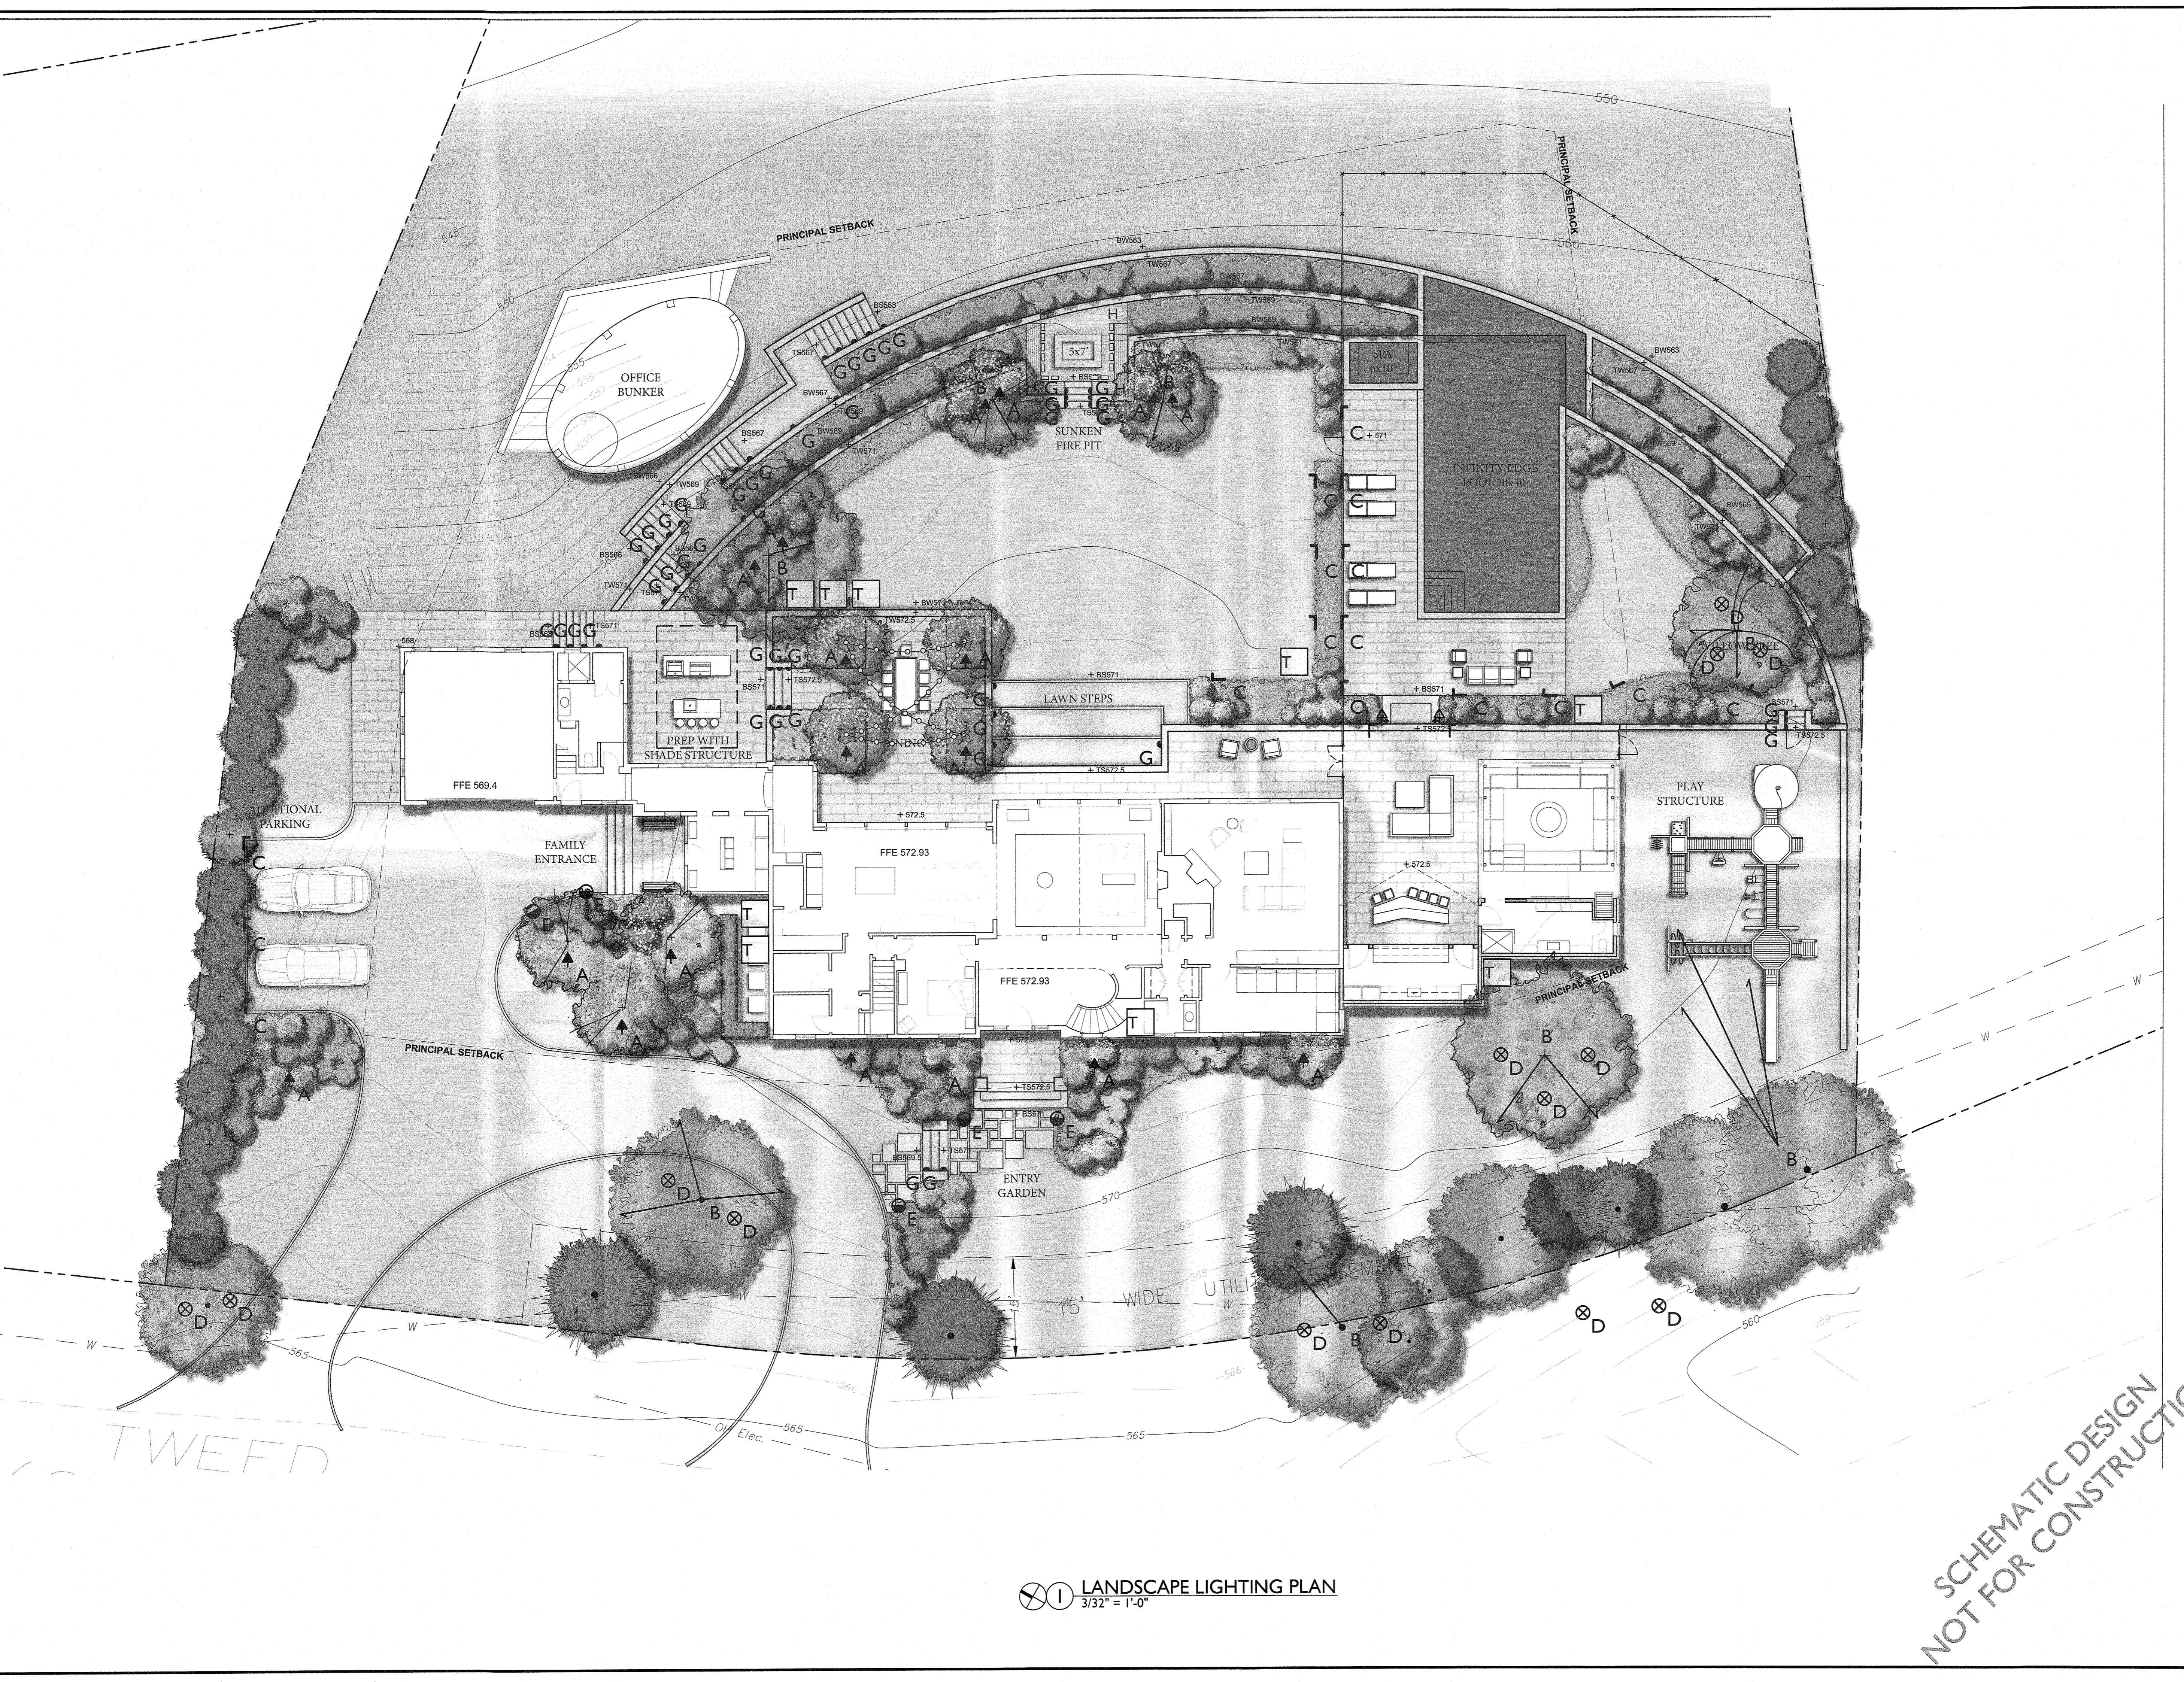

NOTES

- █ LIGHTING BY ORSMAN DESIGN, INC. (ODI)
- █ FIXTURE GROUPING - TYPICAL
- █ FIXTURE GROUPING - PATH
- █ FIXTURE GROUPING - REMOTE DRIVER

LIGHT FIXTURE LEGEND







SYMBOL	TYPE	DESCRIPTION
↑	A	UPLIGHT, ADJUSTABLE HEIGHT
→	B	DOWN LIGHT, TREE MOUNTED MR 16
└┘	C	PATH LIGHT, "L" STYLE
⊗	D	WELL LIGHT
⊙	E	PATH LIGHT, CIRCULAR STYLE
▲	F	STAFF LIGHT
▲	G	STEP LIGHT, IN-WALL
□□□□	H	LINEAR LED, EXTERIOR RATED
◆◆◆◆	J	STRING LIGHTS
⊠		TRANSFORMER
⊙		LINE VOLTAGE J BOX
⊙		LOW VOLTAGE J BOX
⊙		SPARE FEED
⊠		PVC SLEEVE BY OTHERS

DRAWING REVISIONS

I	04.27.2021 - S.D.

PROJECT	PRIVATE RESIDENCE 59 TWEED BLVD NYACK, NY
DWG TITLE	LANDSCAPE LIGHTING CONCEPT IMAGERY
DATE	04.26.2021
SCALE	
SHEET NO.	LC-1.0

SCHEMATIC DESIGN
NOT FOR CONSTRUCTION

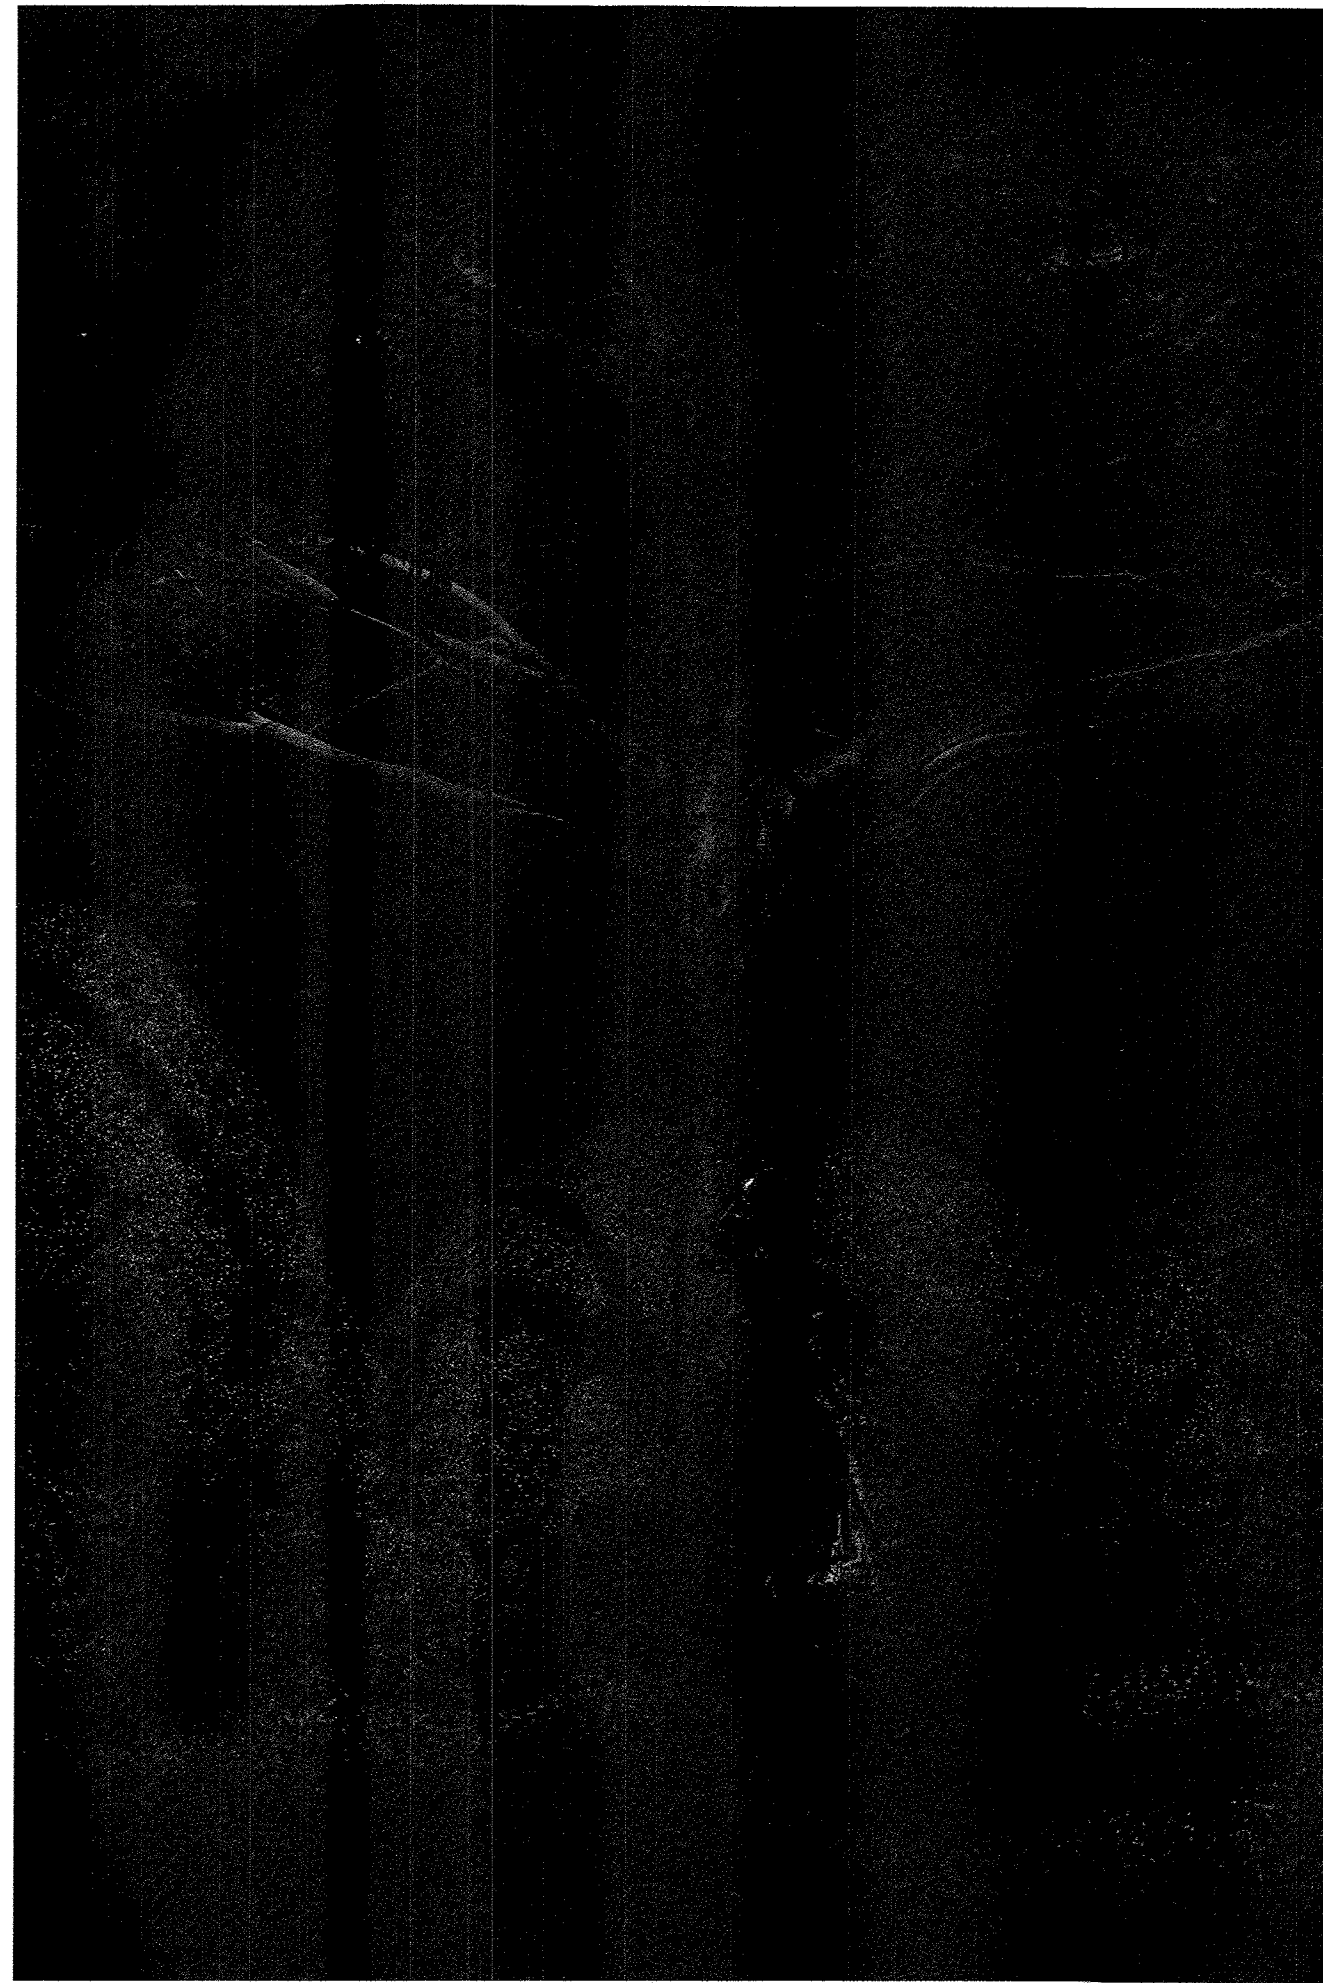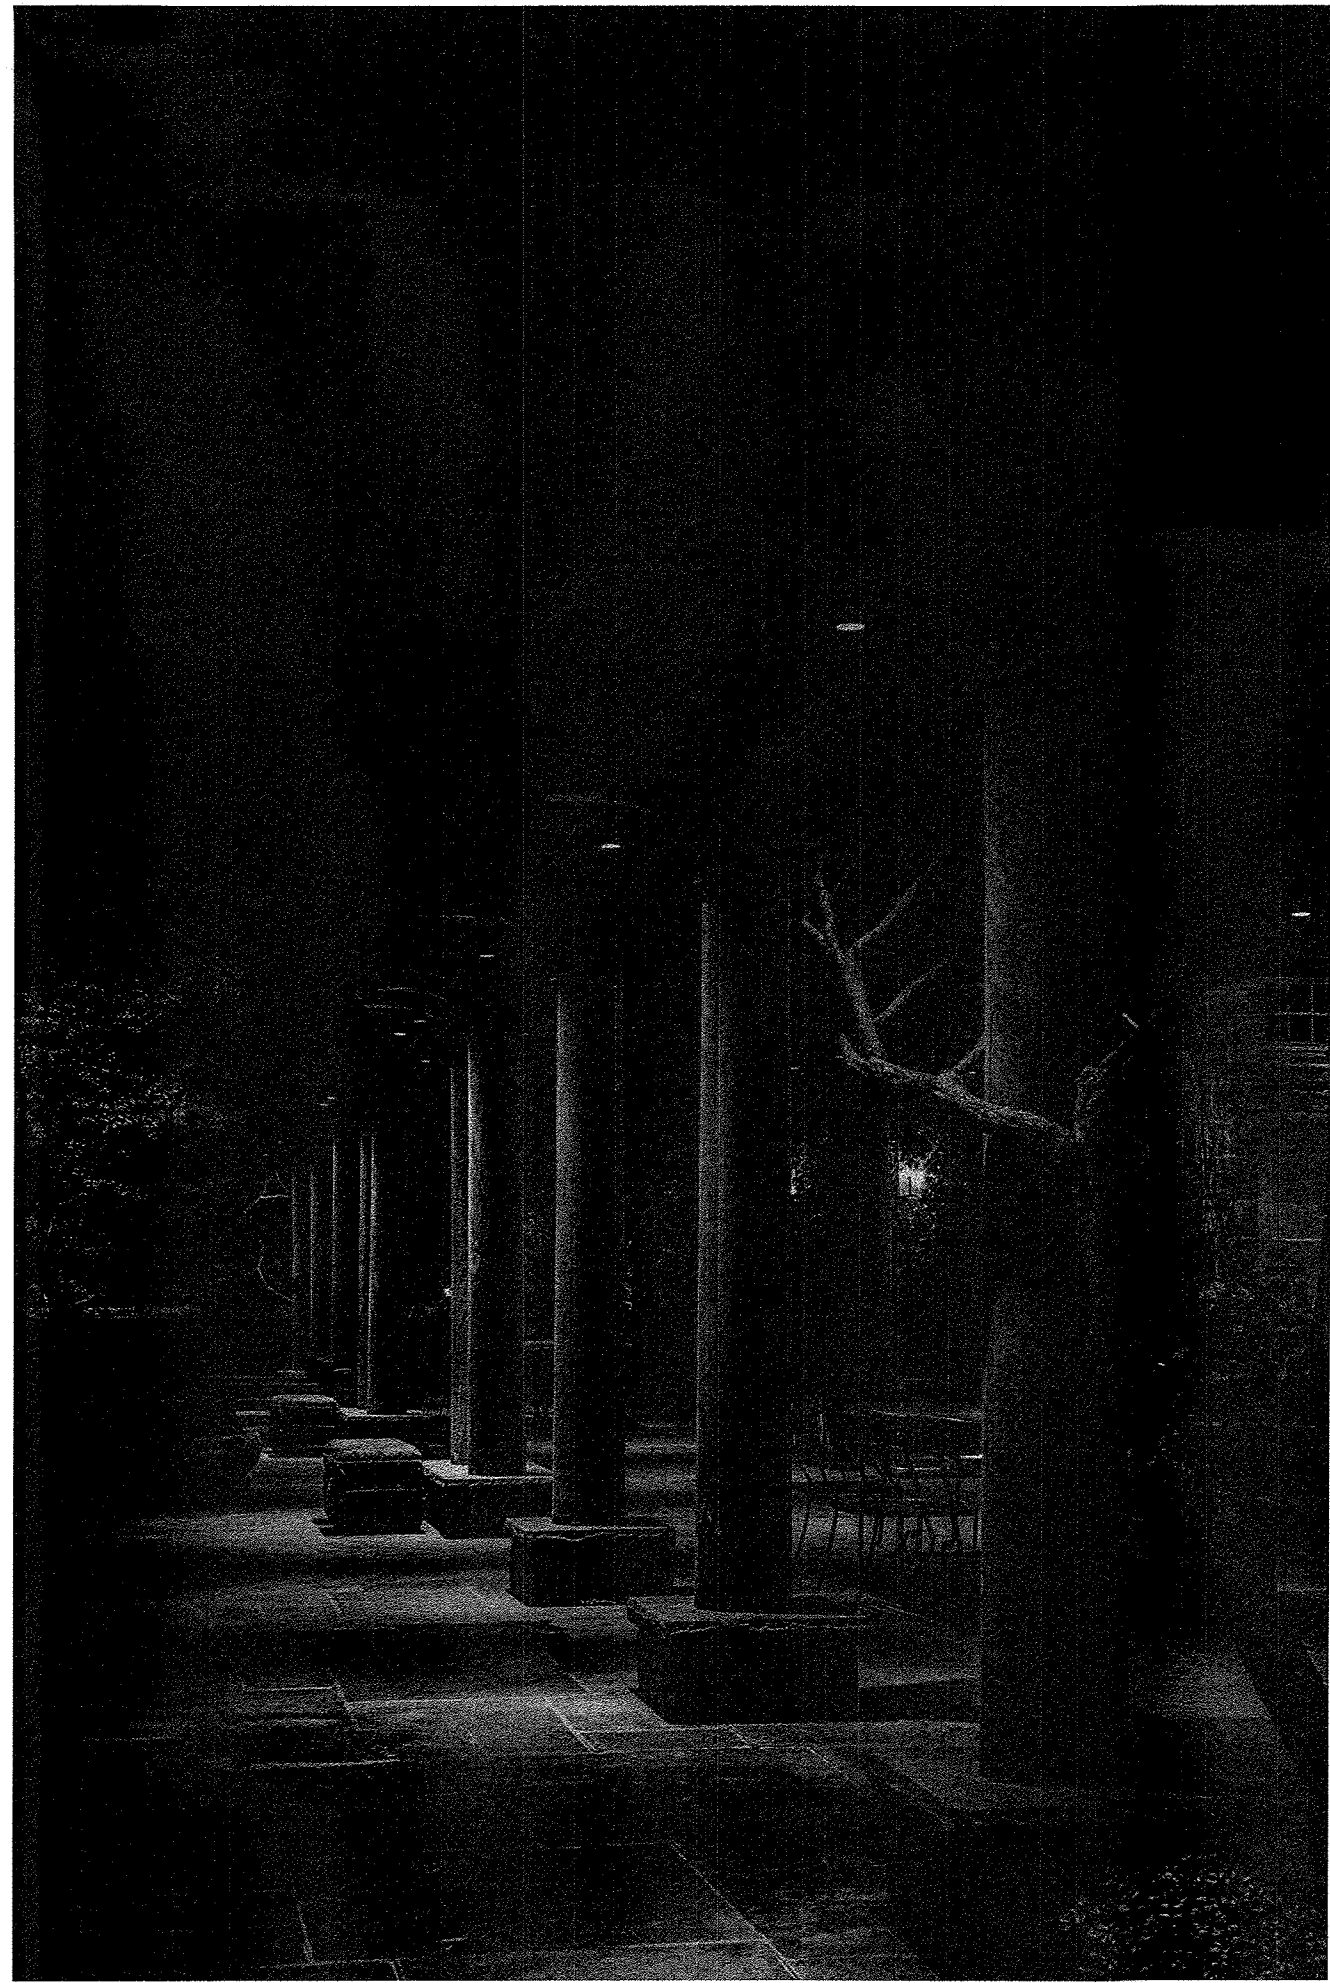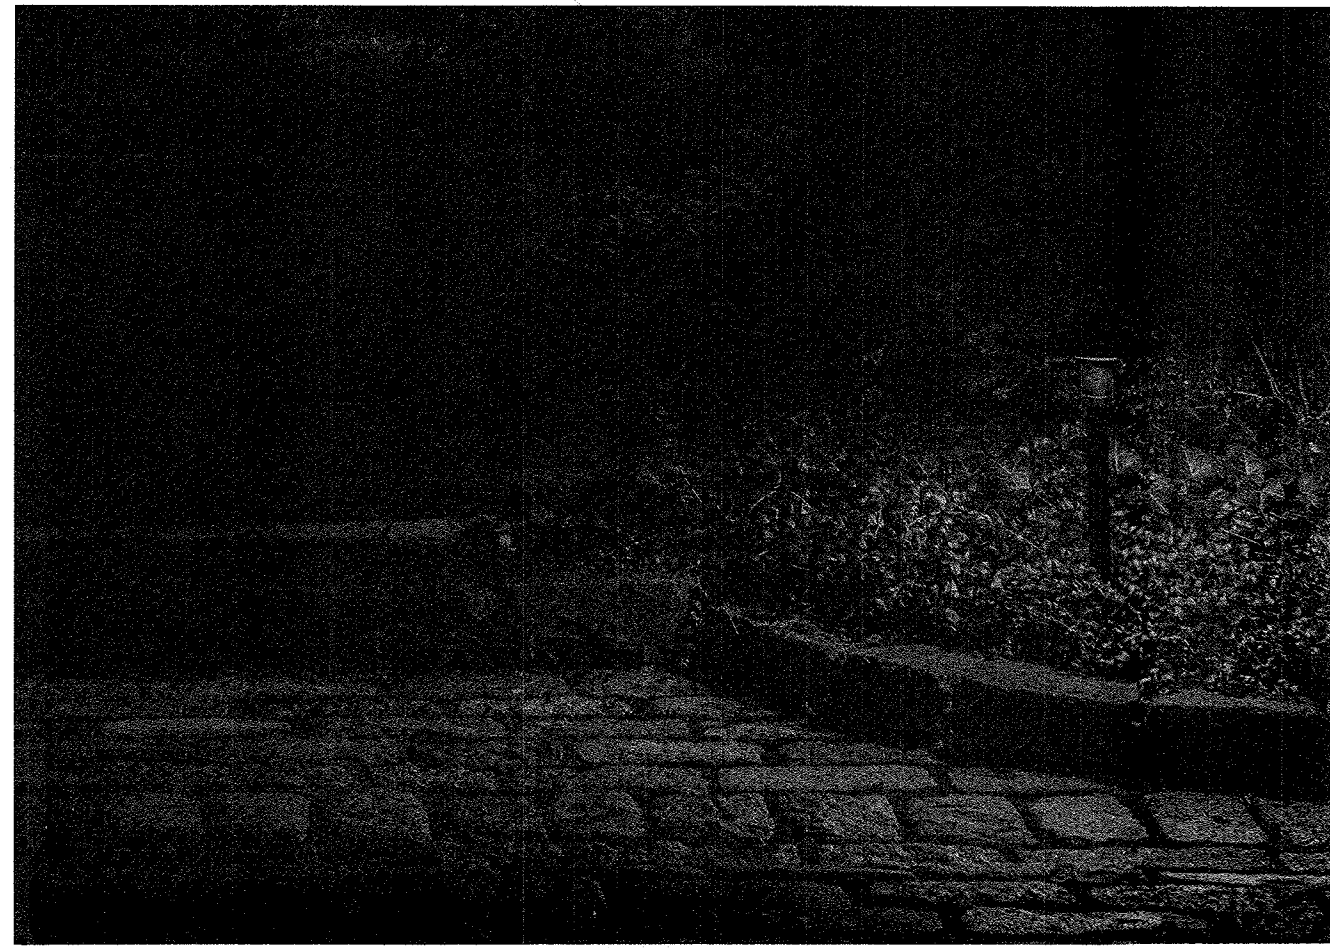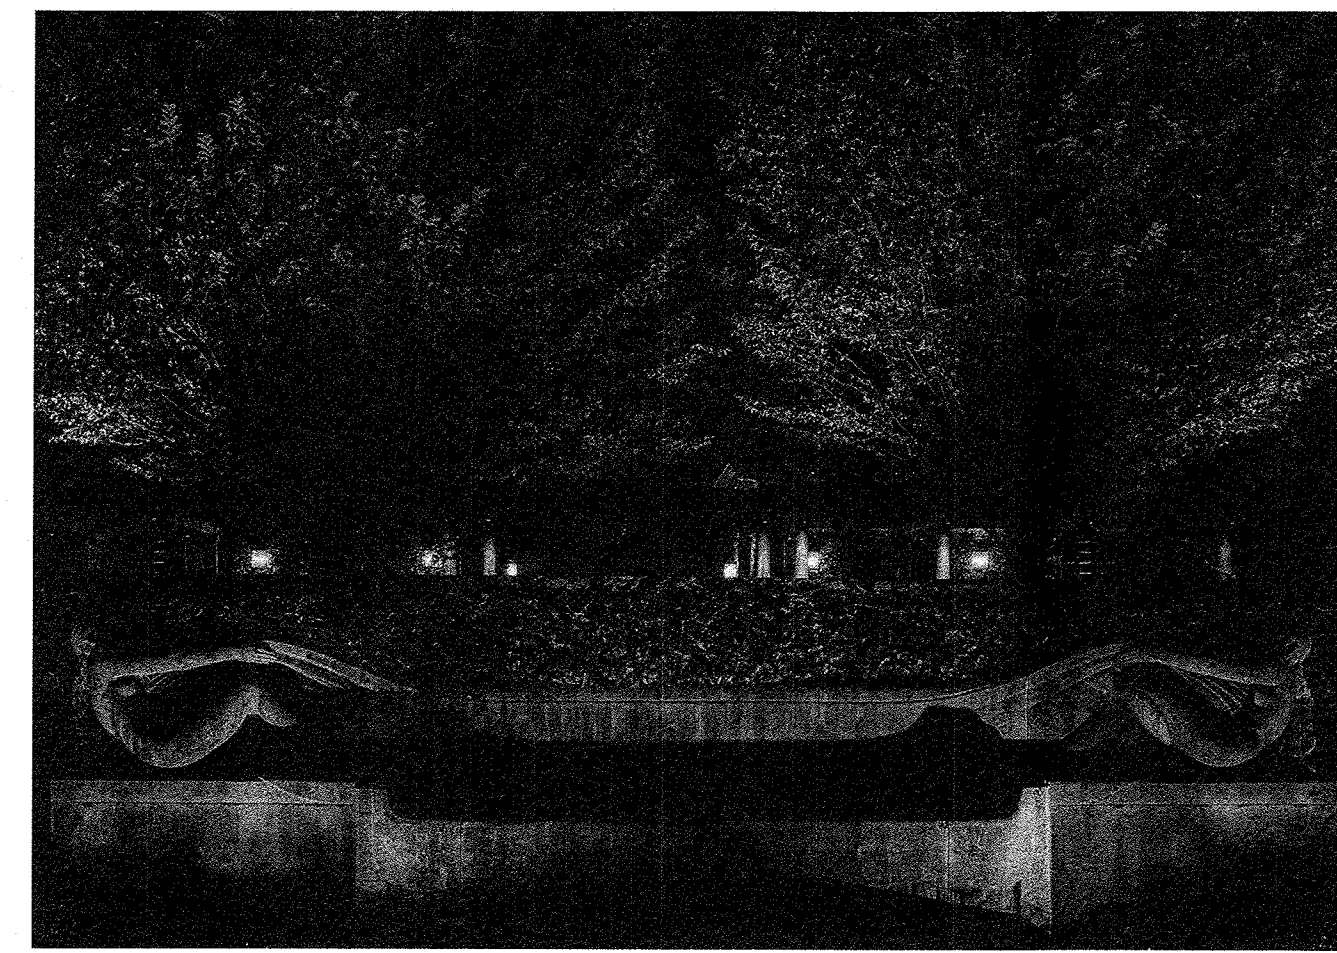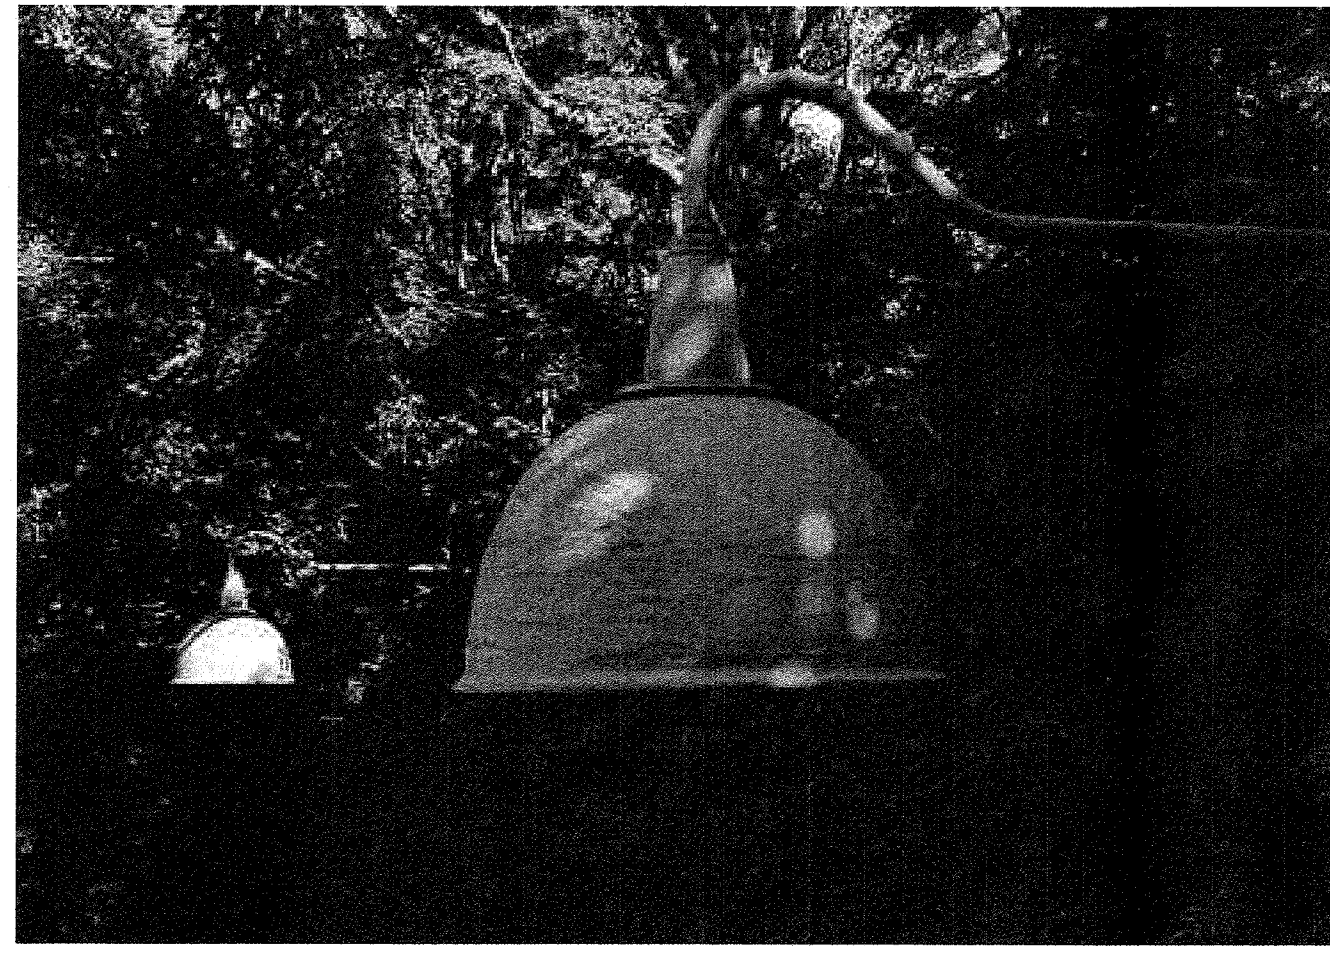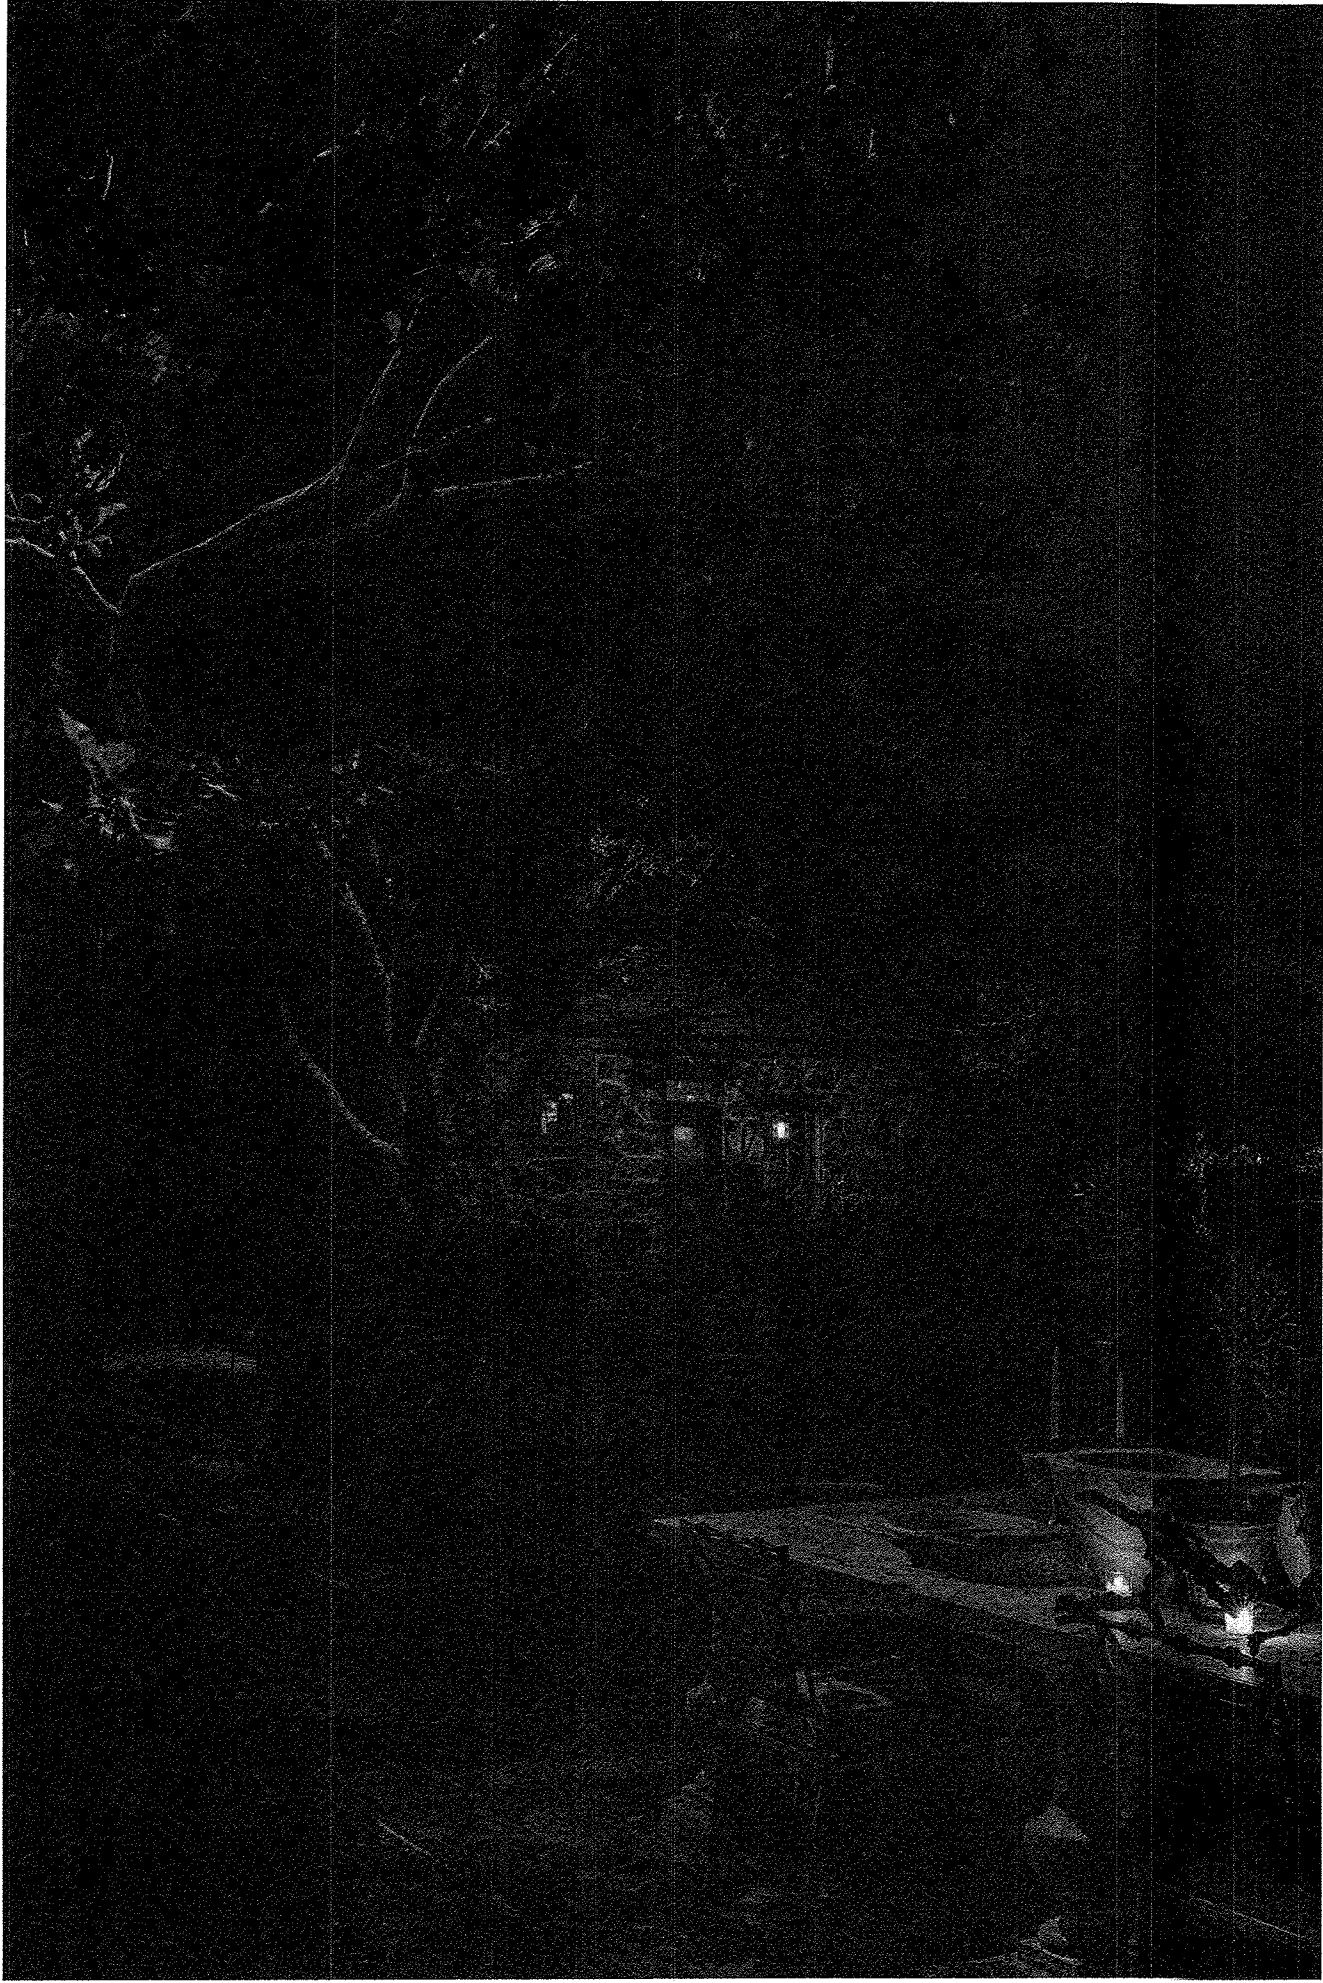

NOTES

- LIGHTING BY ORSMAN DESIGN, INC. (ODI)
- FIXTURE GROUPING - TYPICAL
- FIXTURE GROUPING - PATH
- FIXTURE GROUPING - REMOTE DRIVER

LIGHT FIXTURE LEGEND

SYMBOL	TYPE	DESCRIPTION
▲	A	UPLIGHT, ADJUSTABLE HEIGHT
→	B	DOWN LIGHT, TREE MOUNTED MR 16
└	C	PATH LIGHT, "L" STYLE
⊗	D	WELL LIGHT
⊙	E	PATH LIGHT, CIRCULAR STYLE
▲	F	STAFF LIGHT
•	G	STEP LIGHT, IN-WALL
□□□□	H	LINEAR LED, EXTERIOR RATED
•••••	J	STRING LIGHTS
⊞		TRANSFORMER
⊙		LINE VOLTAGE J BOX
⊙		LOW VOLTAGE J BOX
⊙		SPARE FEED
└		PVC SLEEVE BY OTHERS

DRAWING REVISIONS

NO.	DATE	DESCRIPTION
I	04.27.2021	- S.D.










PROJECT PRIVATE RESIDENCE
59 TWEED BLVD
NYACK, NY

DWG TITLE LANDSCAPE
LIGHTING CONCEPT
IMAGERY

DATE 04.26.2021

SCALE

SHEET NO. LC-1.1

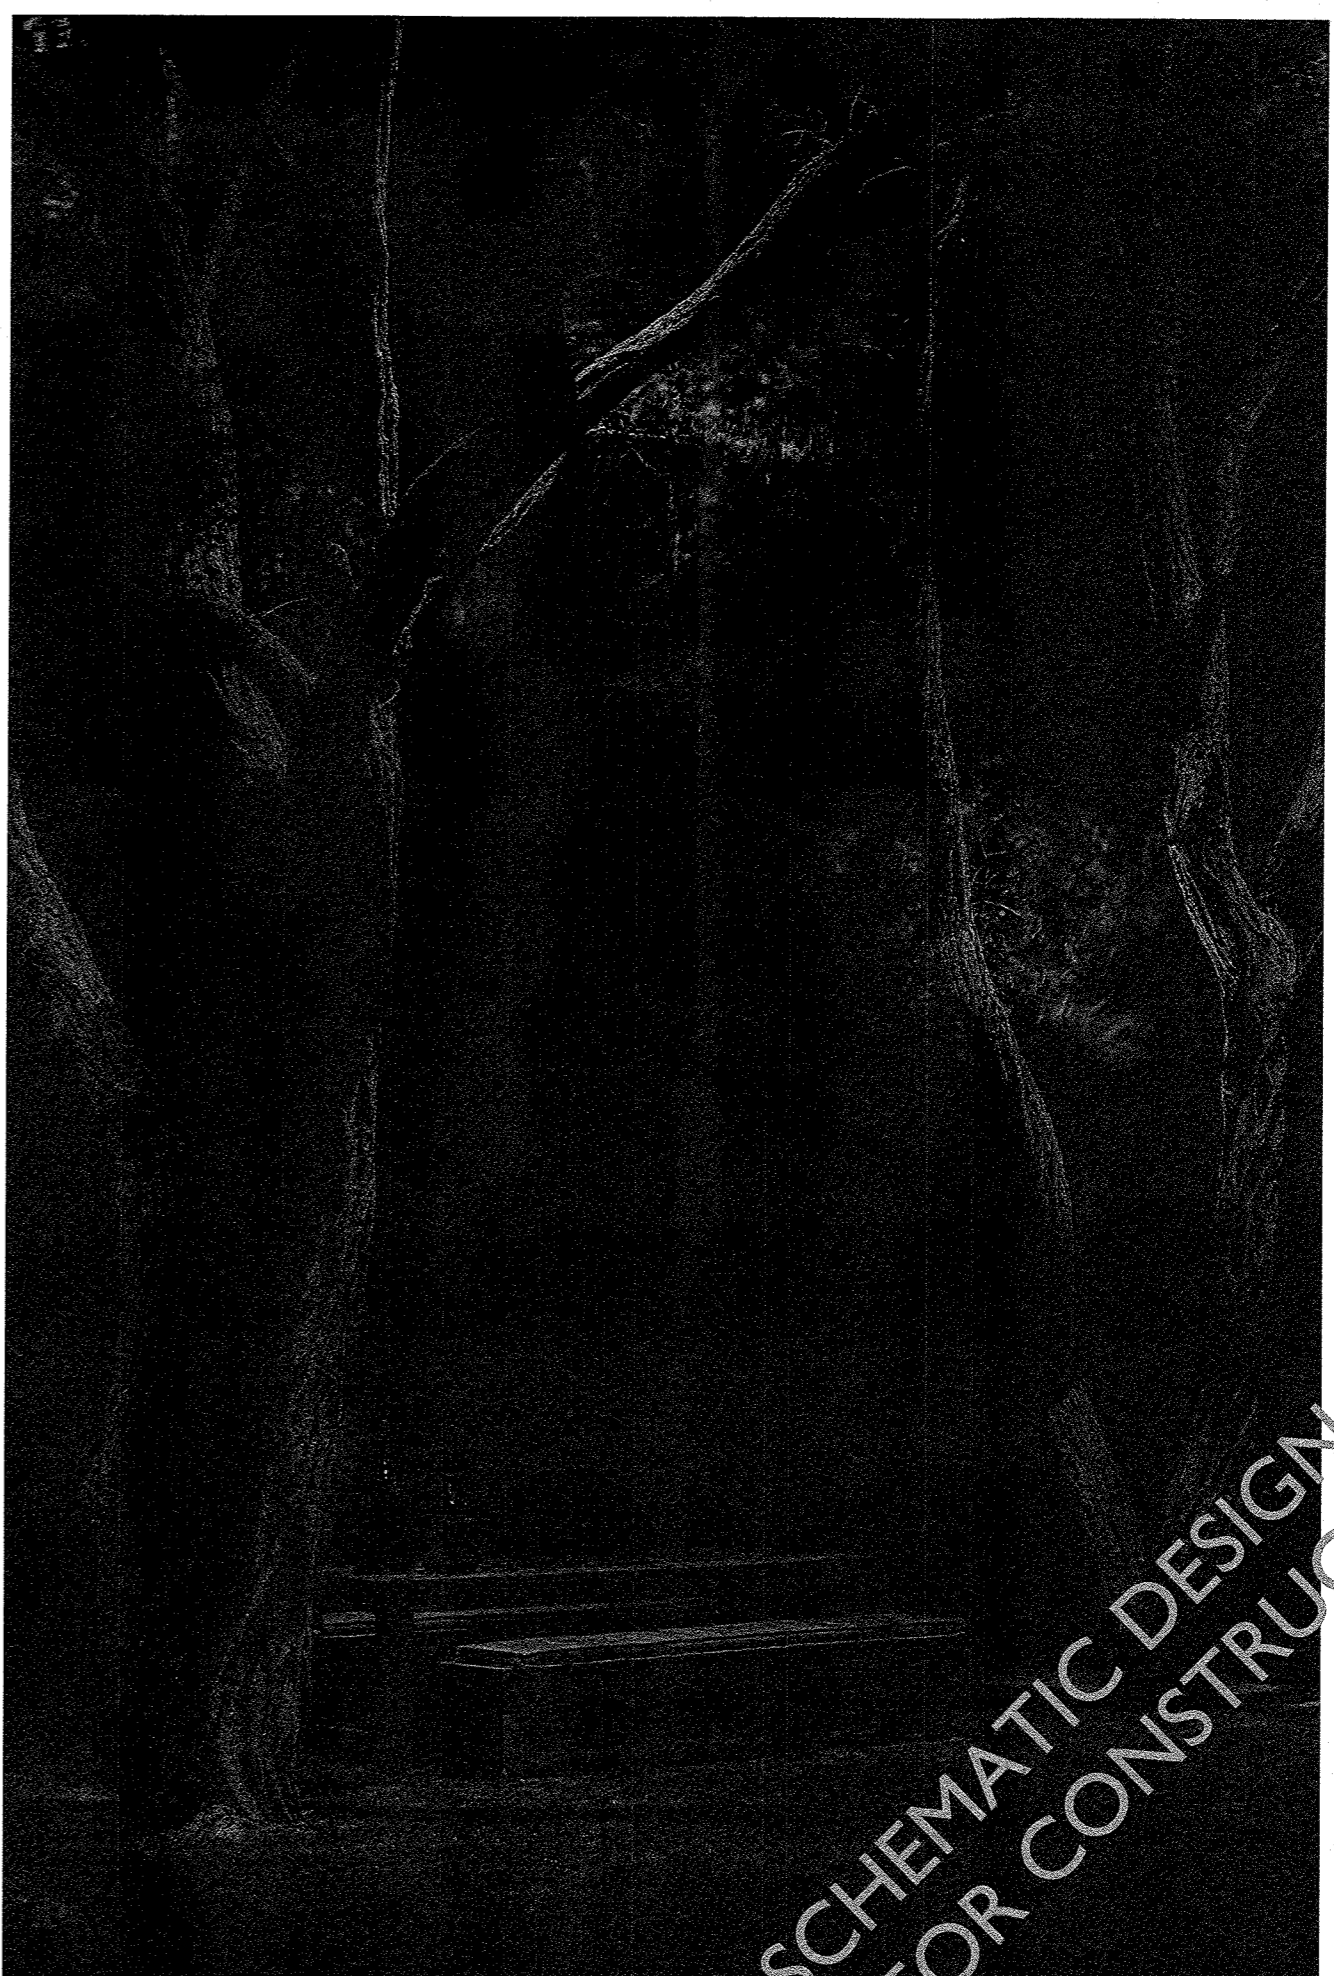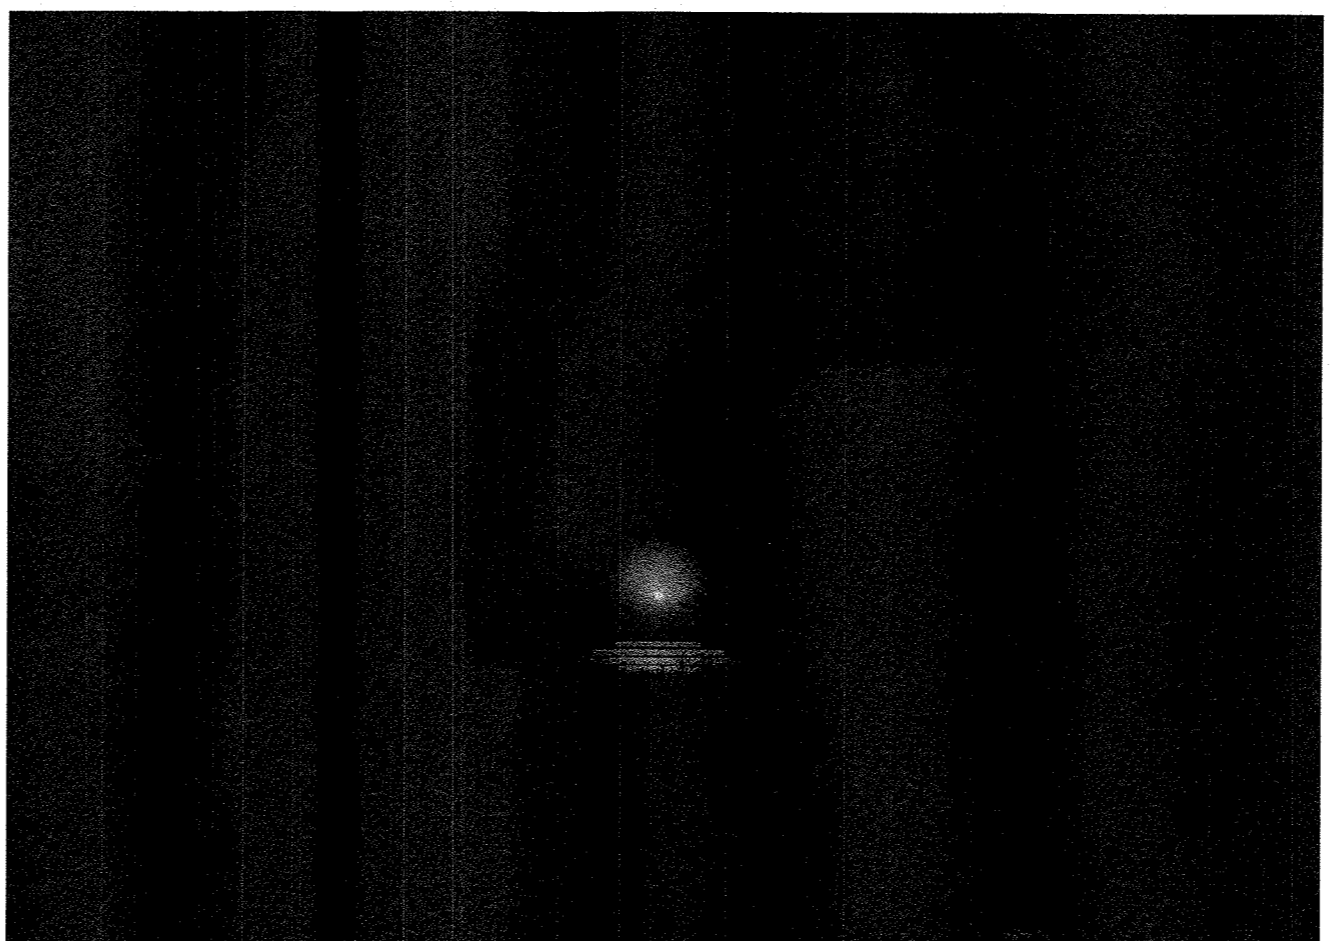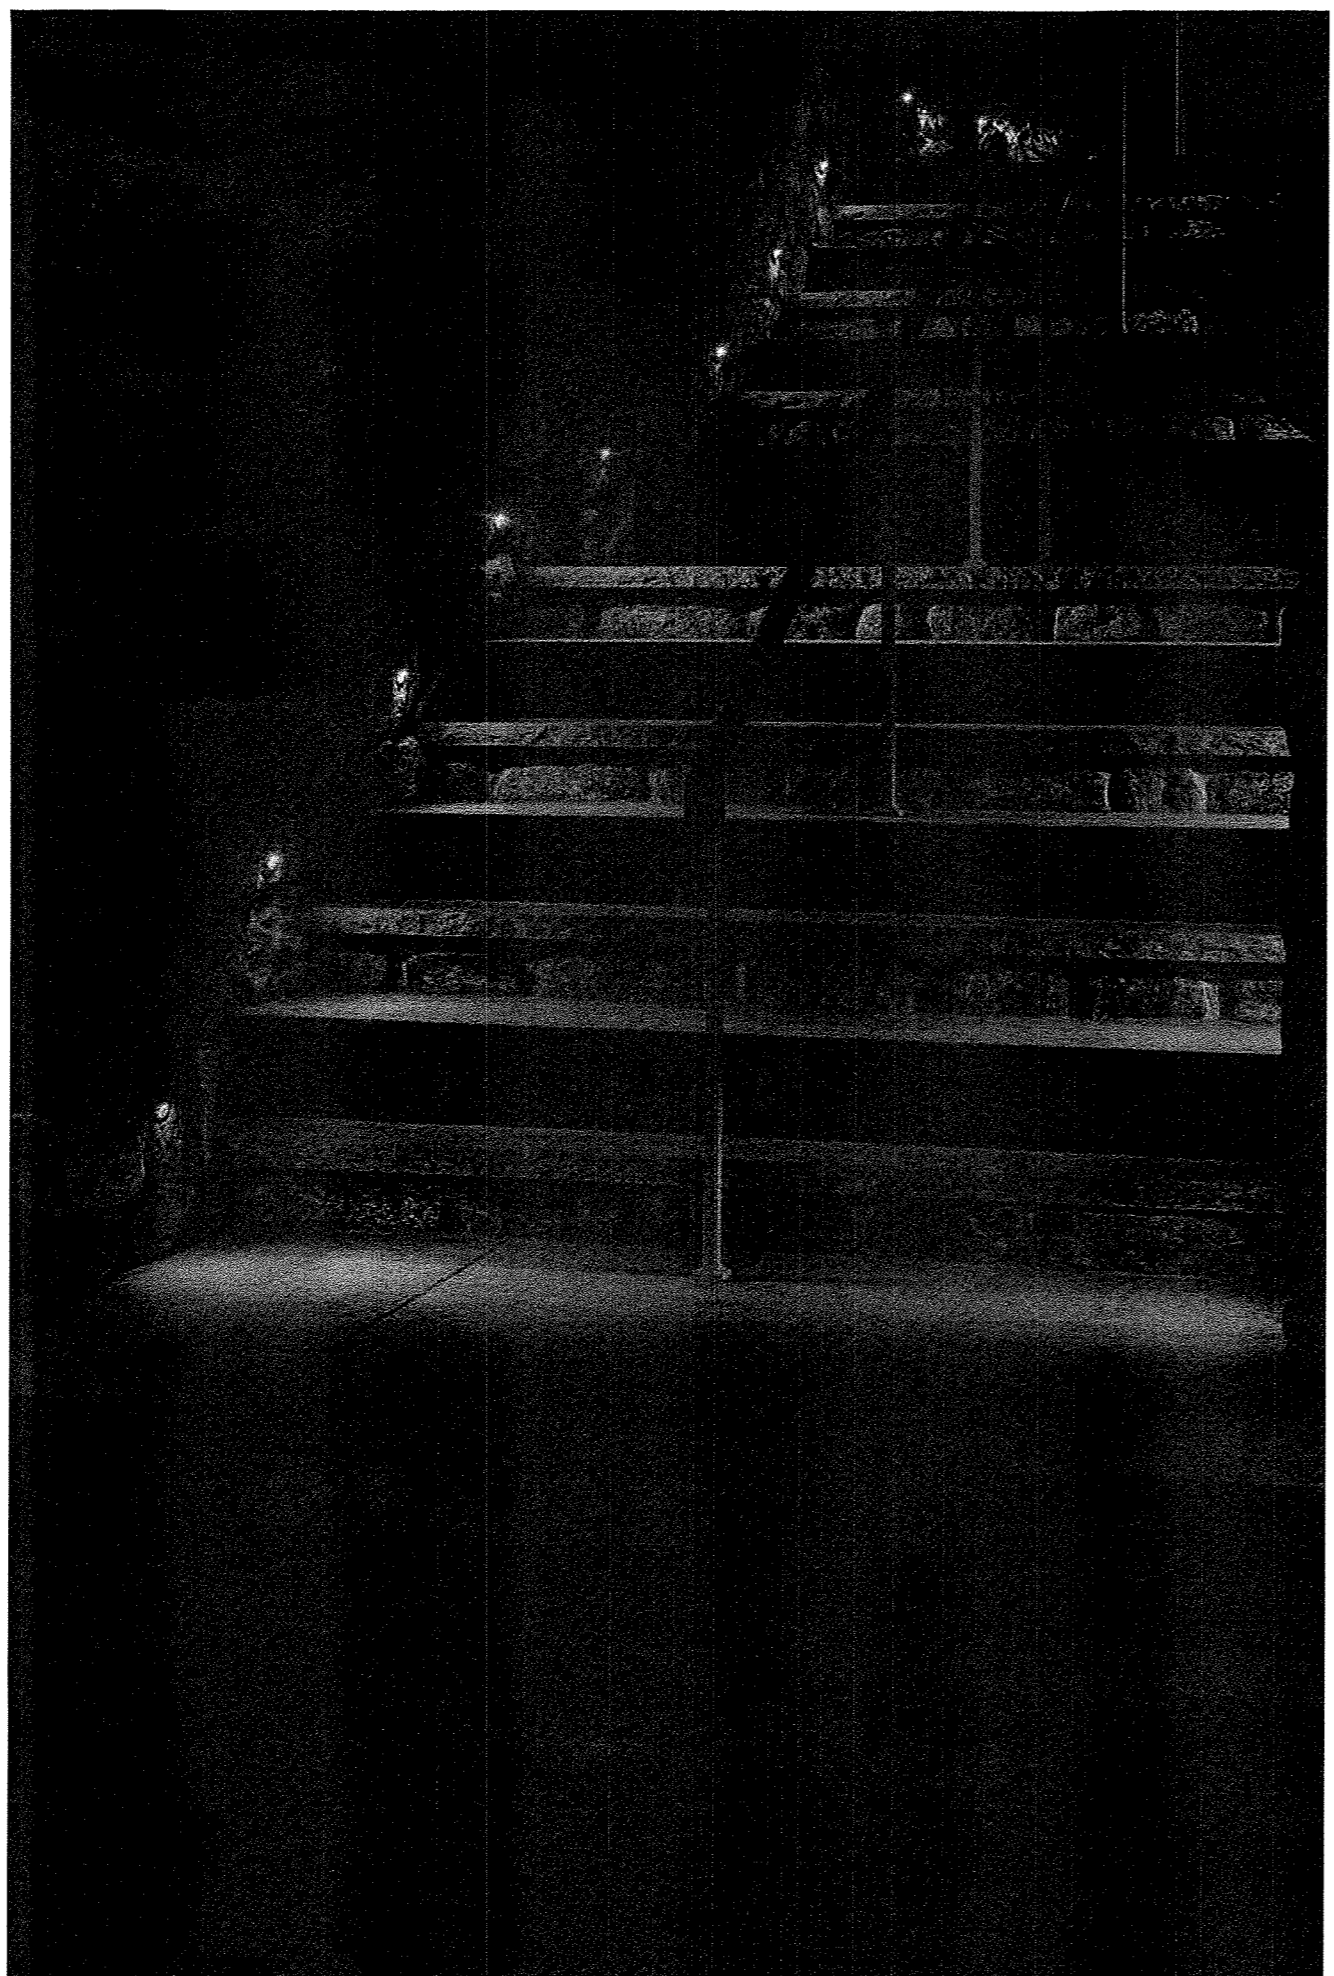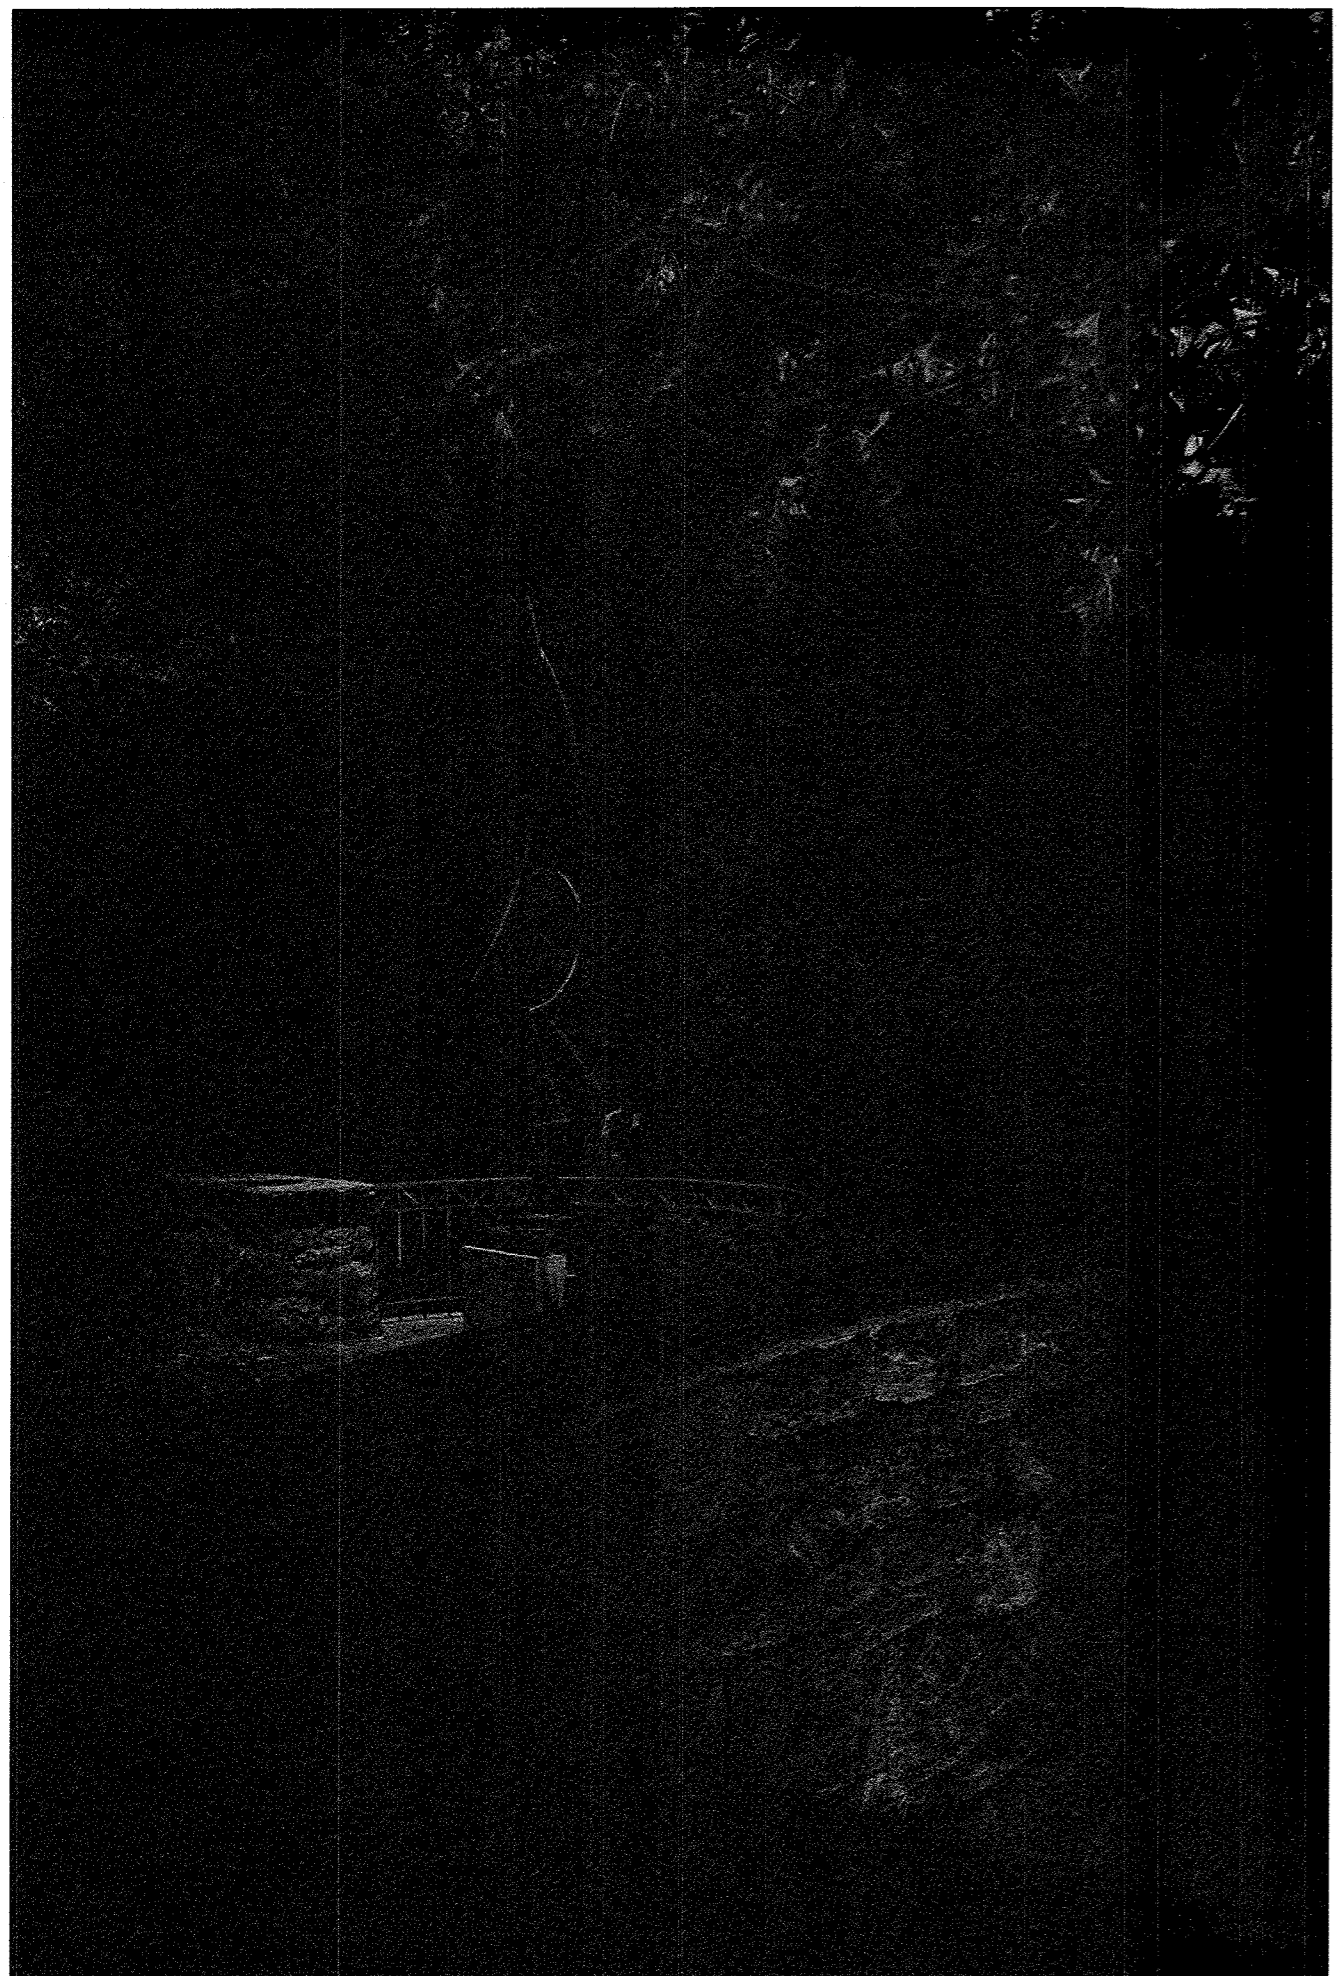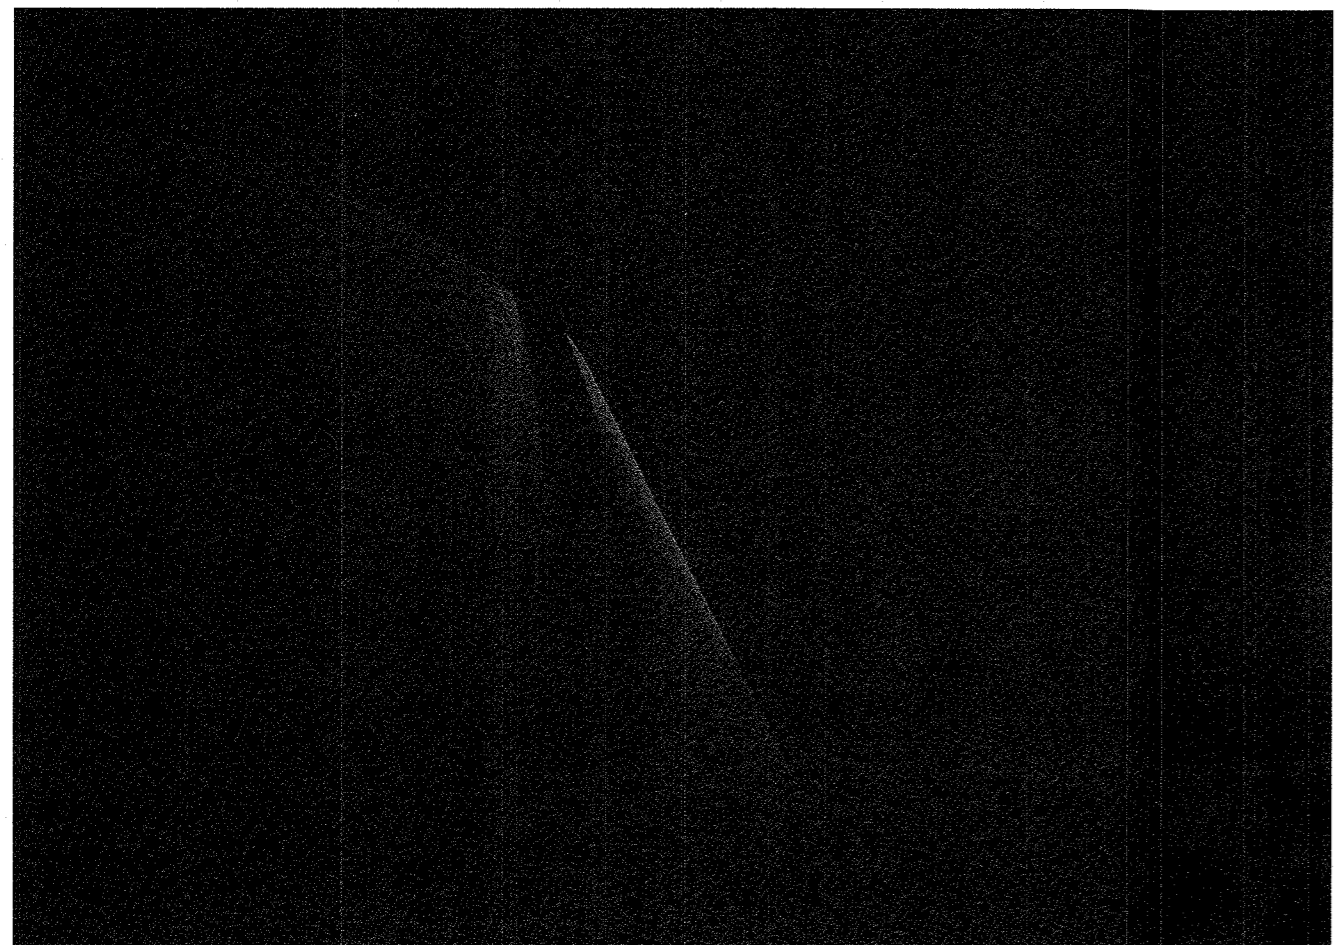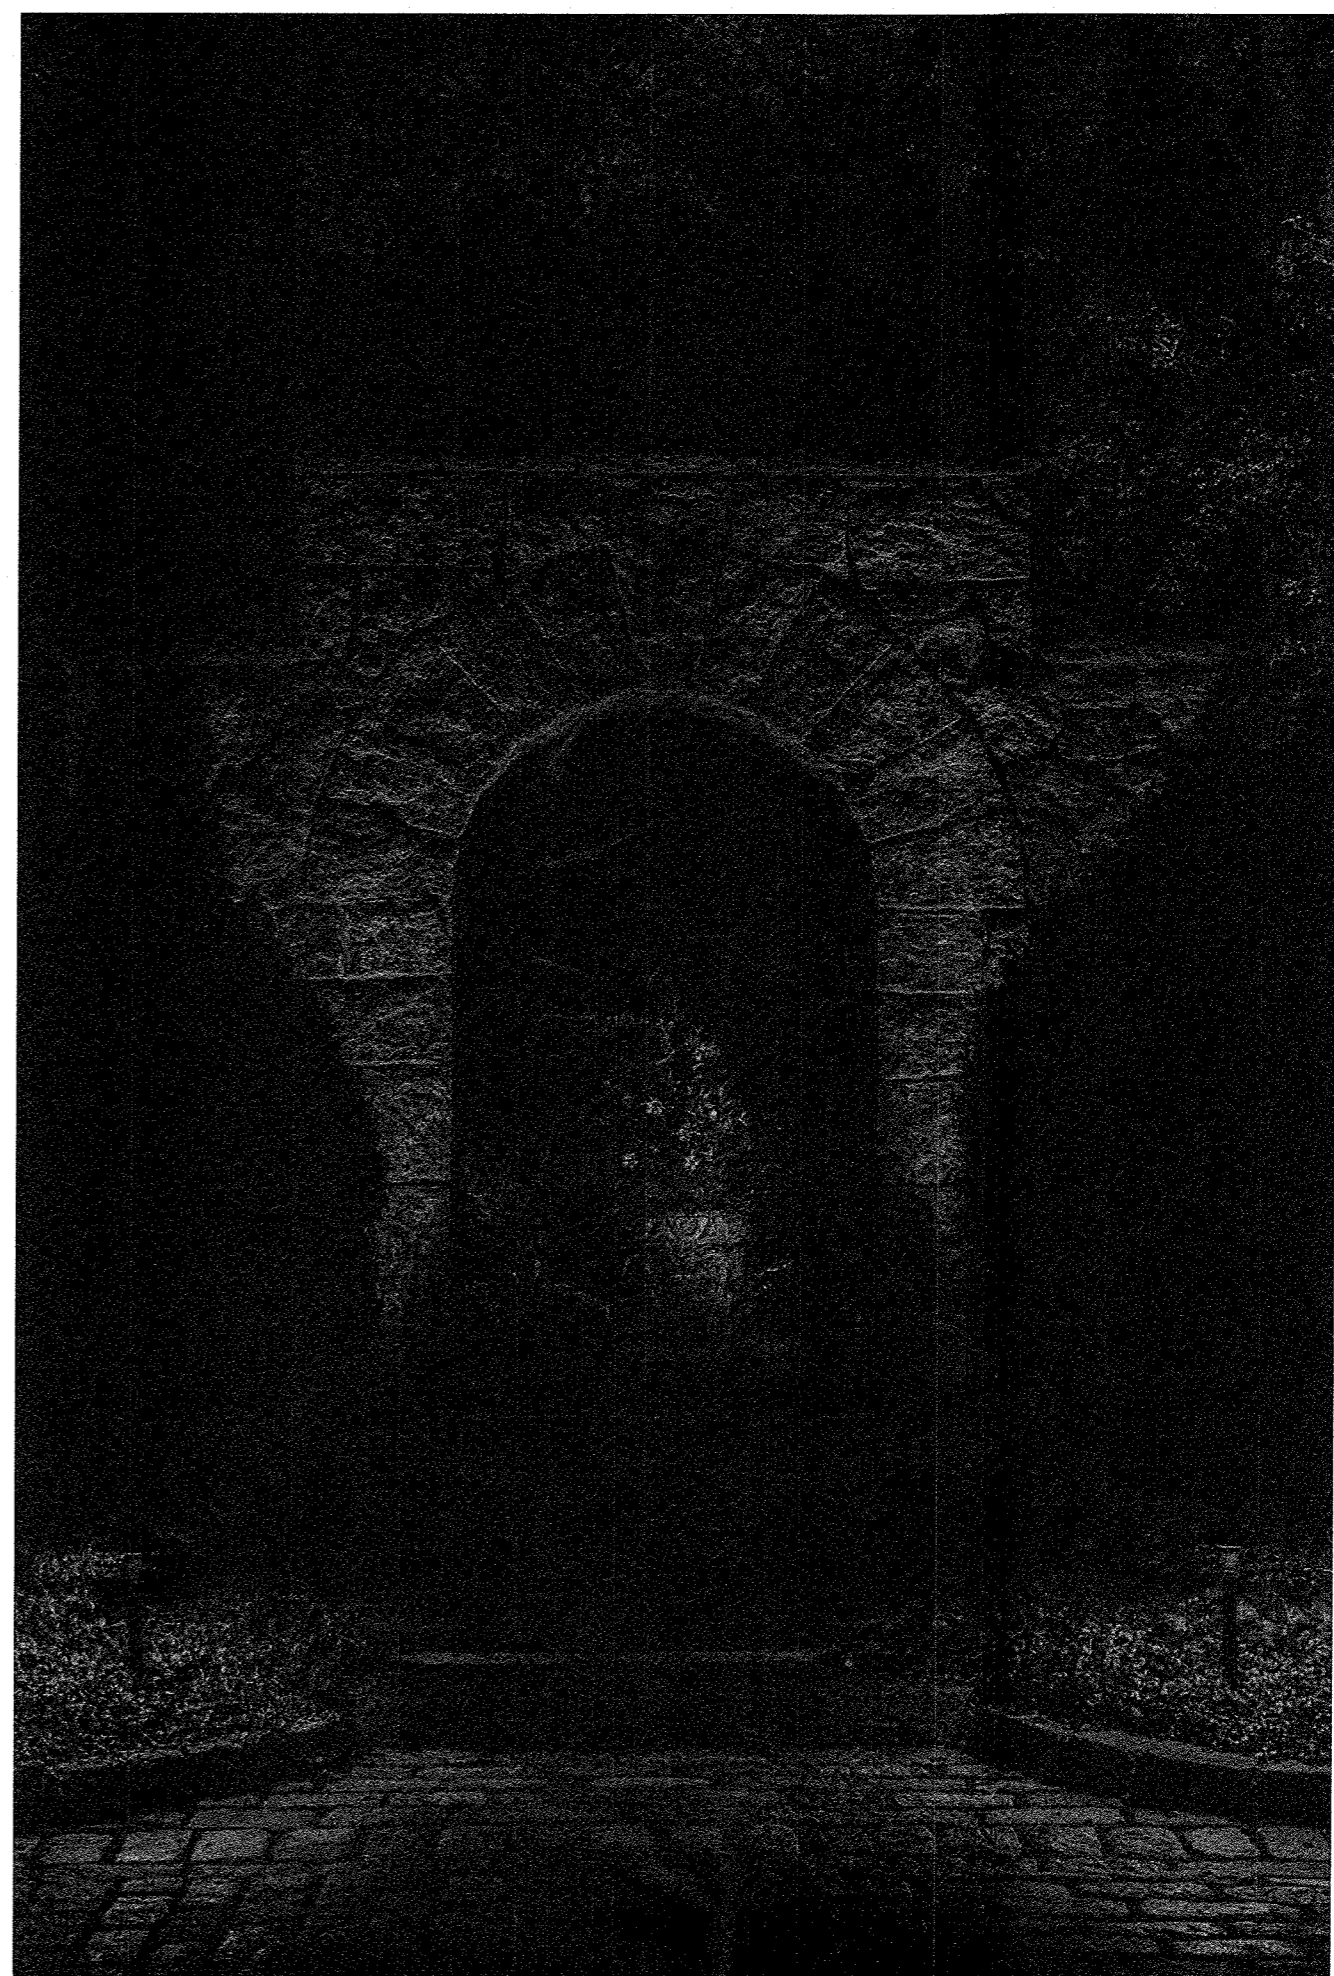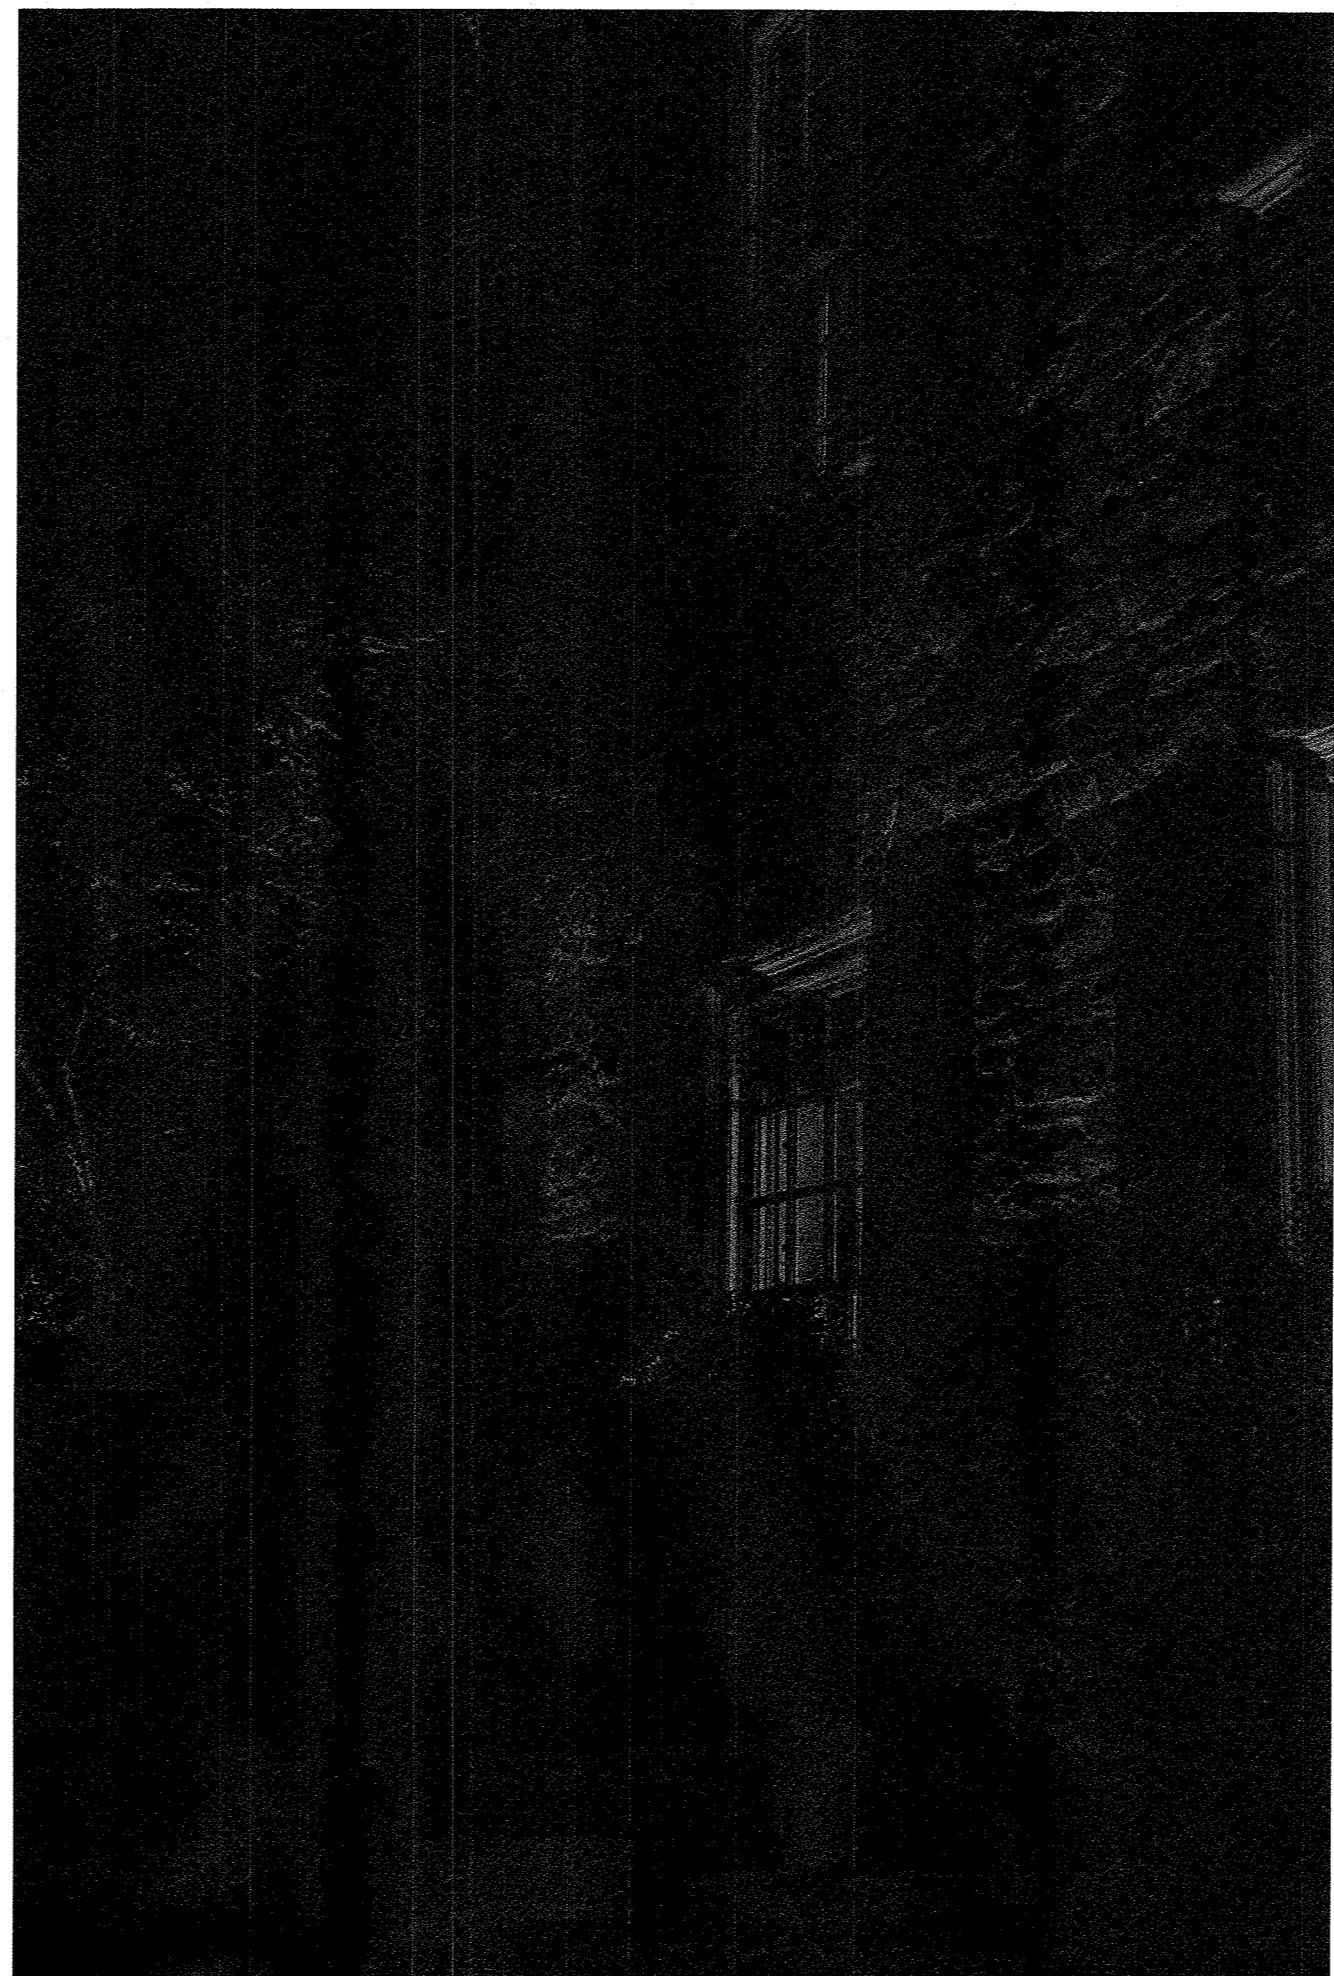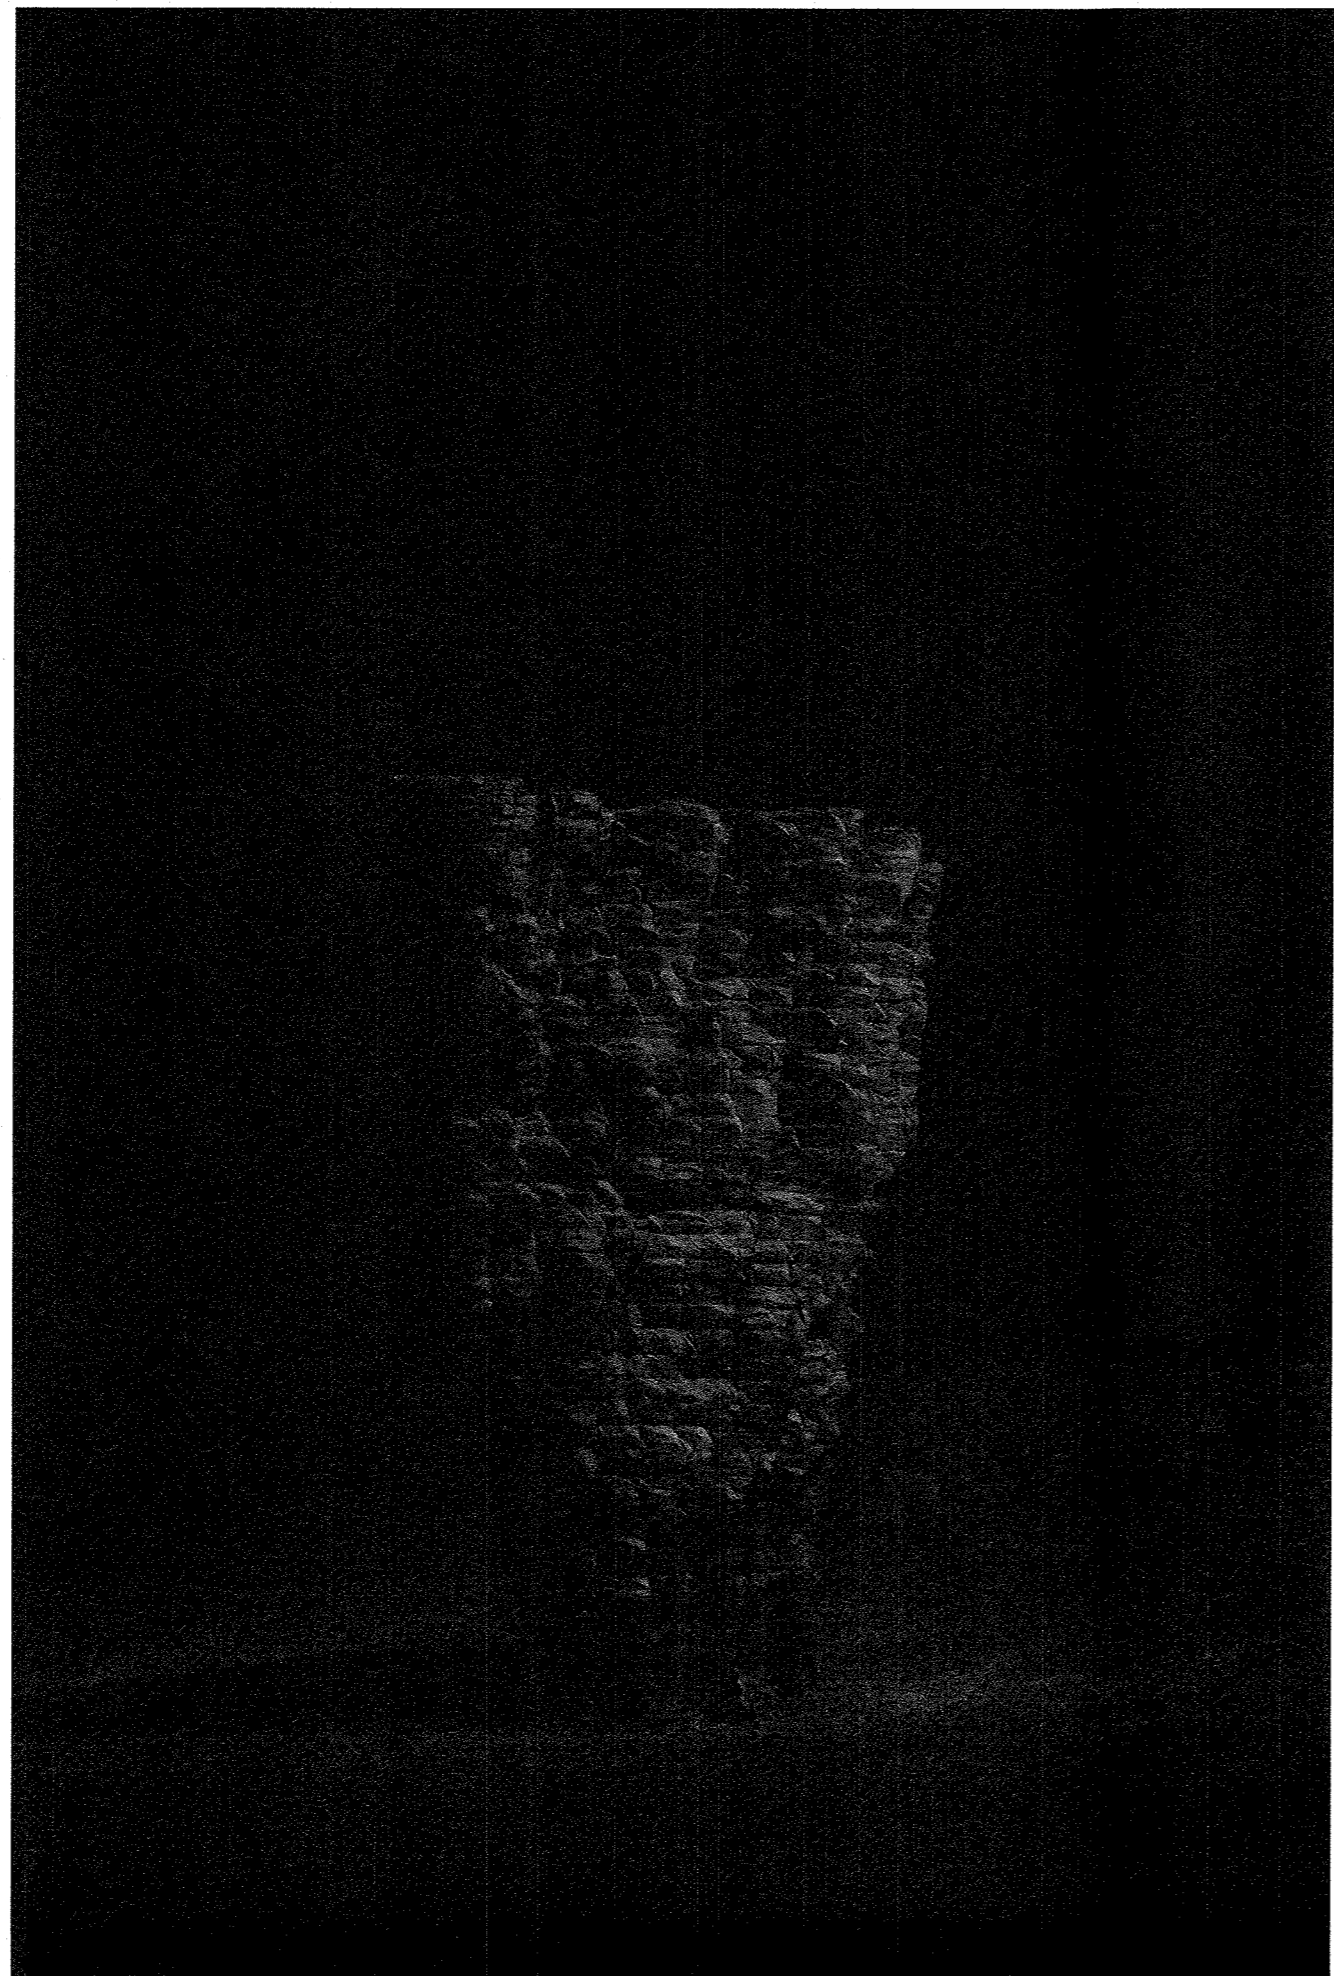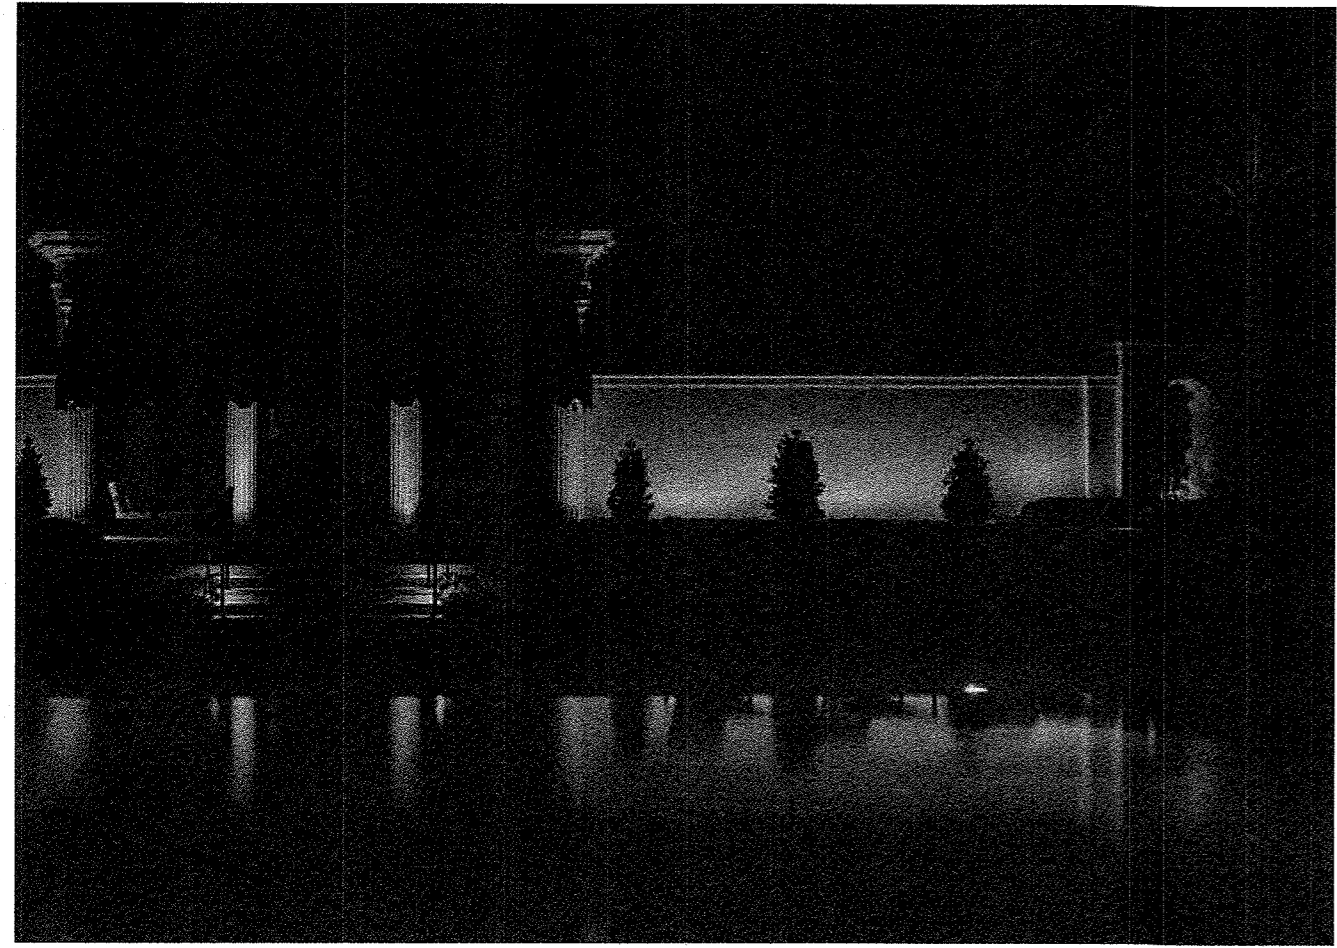

SCHEMATIC DESIGN
NOT FOR CONSTRUCTION

NOTES

- LIGHTING BY ORSMAN DESIGN, INC. (ODI)
- FIXTURE GROUPING - TYPICAL
- FIXTURE GROUPING - PATH
- FIXTURE GROUPING - REMOTE DRIVER


LIGHT FIXTURE LEGEND

SYMBOL	TYPE	DESCRIPTION
	A	UPLIGHT, ADJUSTABLE HEIGHT
	B	DOWN LIGHT, TREE MOUNTED MR 16
	C	PATH LIGHT, "L" STYLE
	D	WELL LIGHT
	E	PATH LIGHT, CIRCULAR STYLE
	F	STAFF LIGHT
	G	STEP LIGHT, IN-WALL
	H	LINEAR LED, EXTERIOR RATED
	J	STRING LIGHTS
		TRANSFORMER
		LINE VOLTAGE J BOX
		LOW VOLTAGE J BOX
		SPARE FEED
		PVC SLEEVE BY OTHERS


DRAWING REVISIONS

1	04.27.2021 - S.D.
---	-------------------

PROJECT	PRIVATE RESIDENCE 59 TWEED BLVD NYACK, NY
DWG TITLE	LANDSCAPE LIGHTING CONCEPT IMAGERY
DATE	04.26.2021
SCALE	
SHEET NO.	LC-1.2

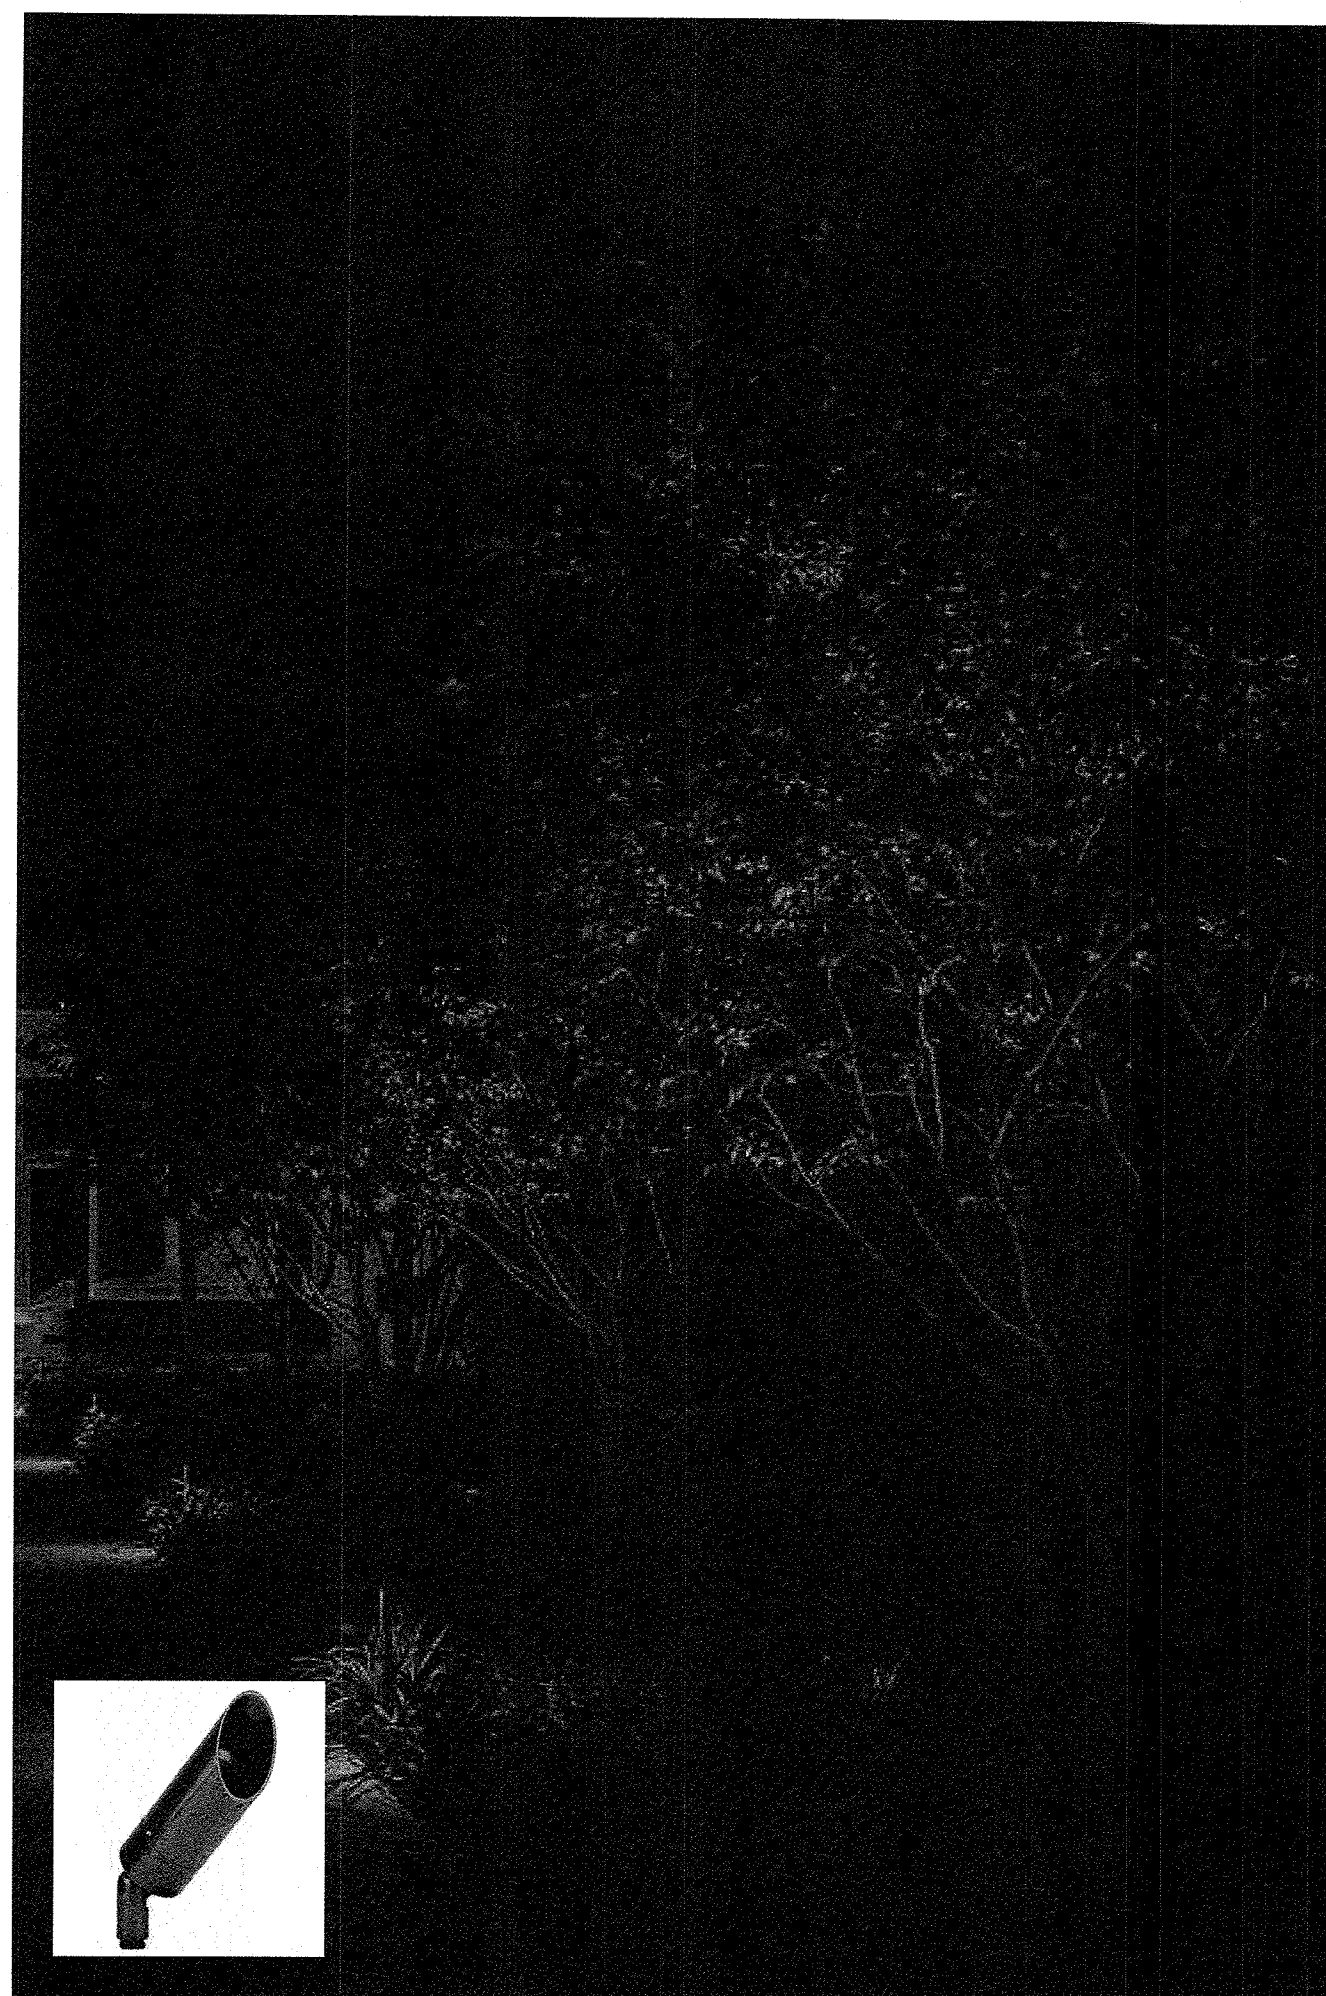

TYPE A/B UPLIGHT/DOWNLIGHT

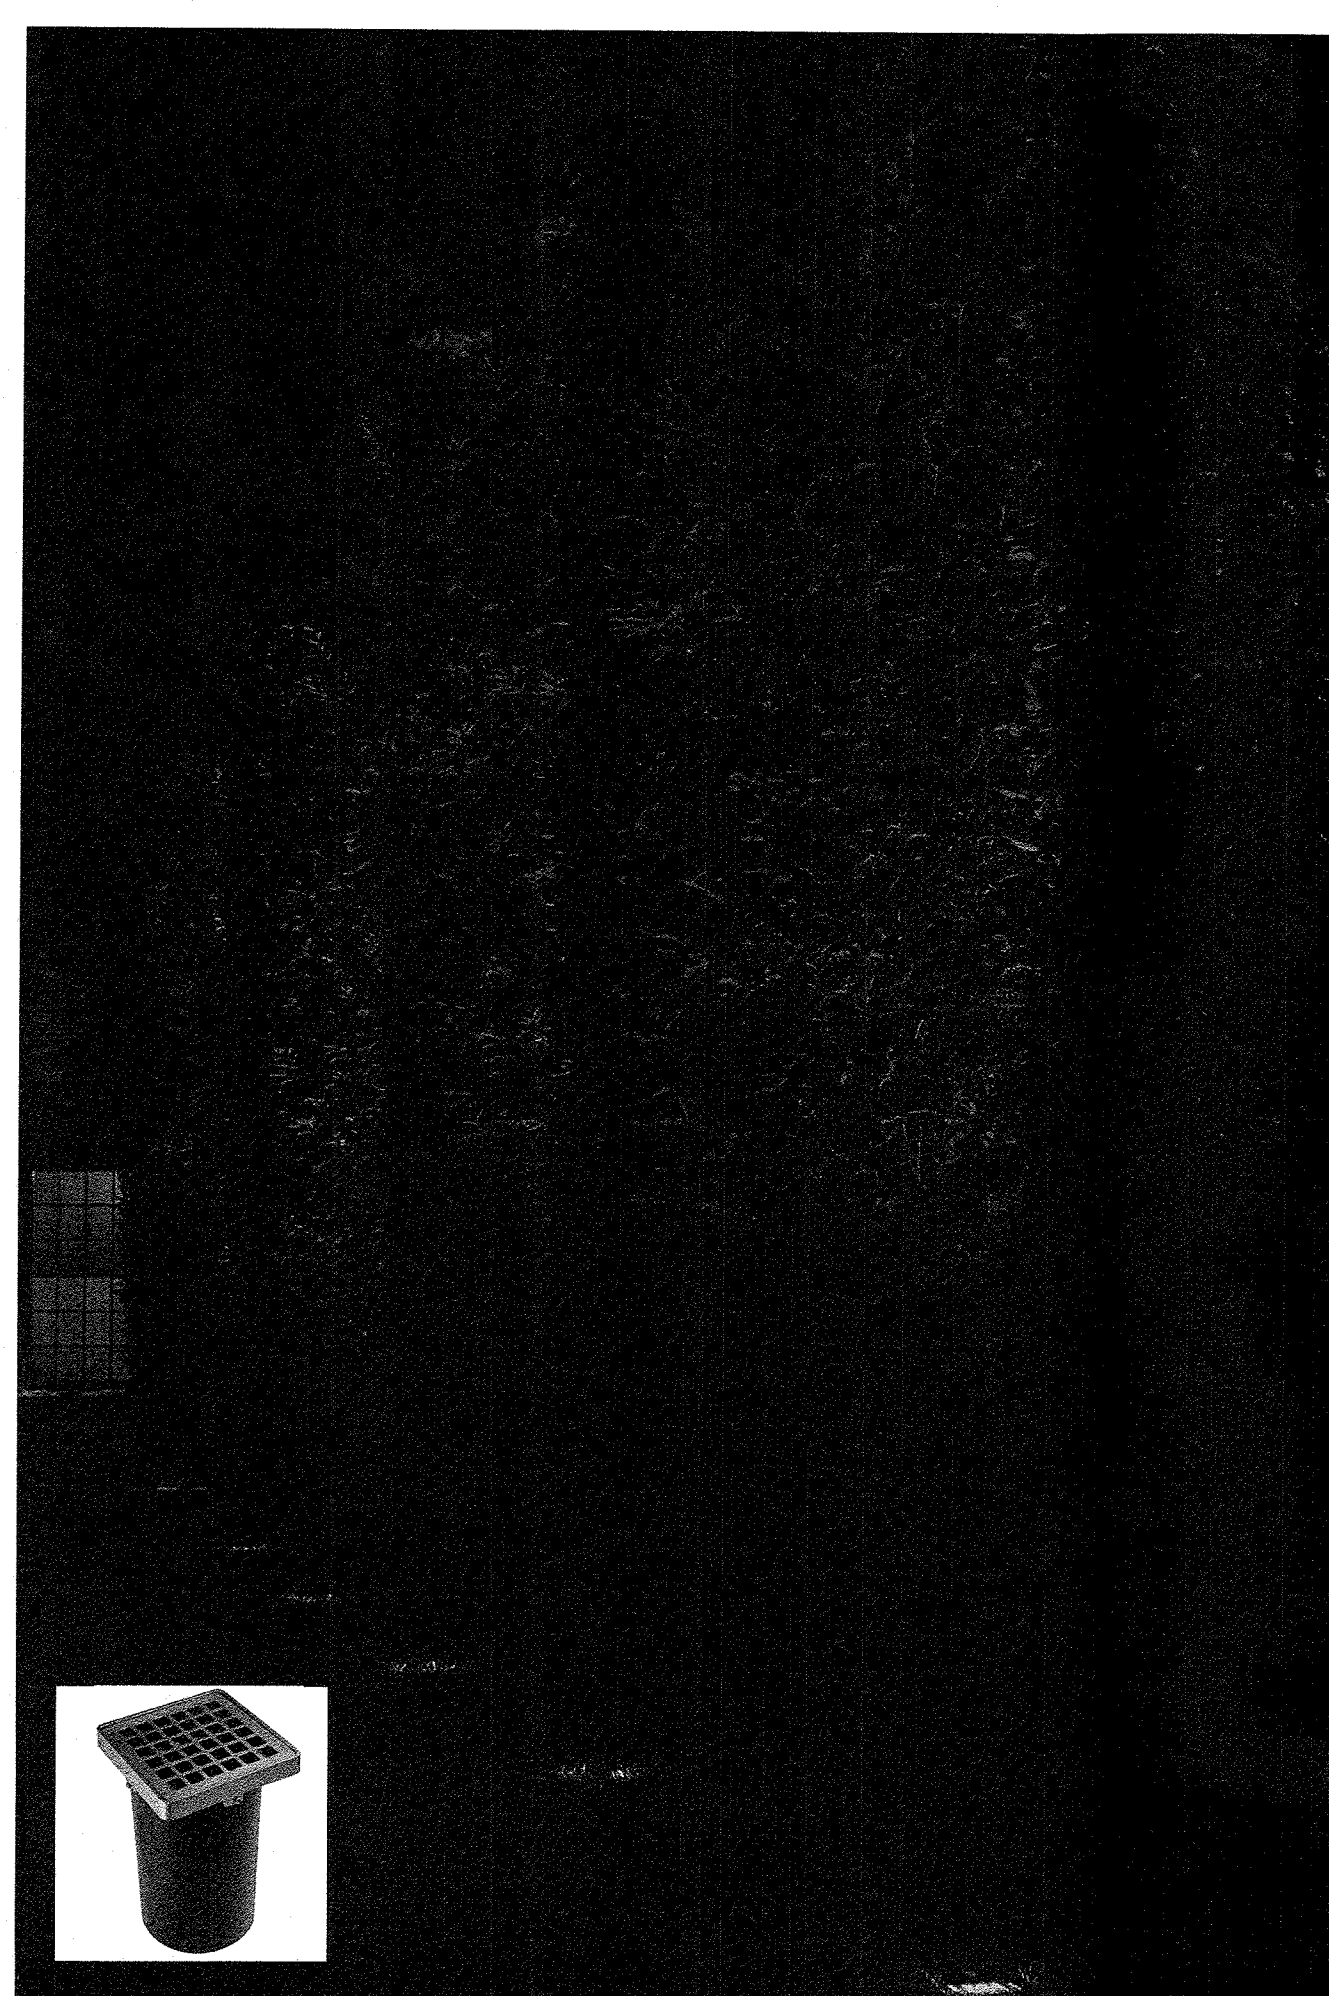


TYPE D WELL LIGHT




TYPE F STAFF LIGHT



TYPE H LINEAR LED, EXTERIOR-RATED

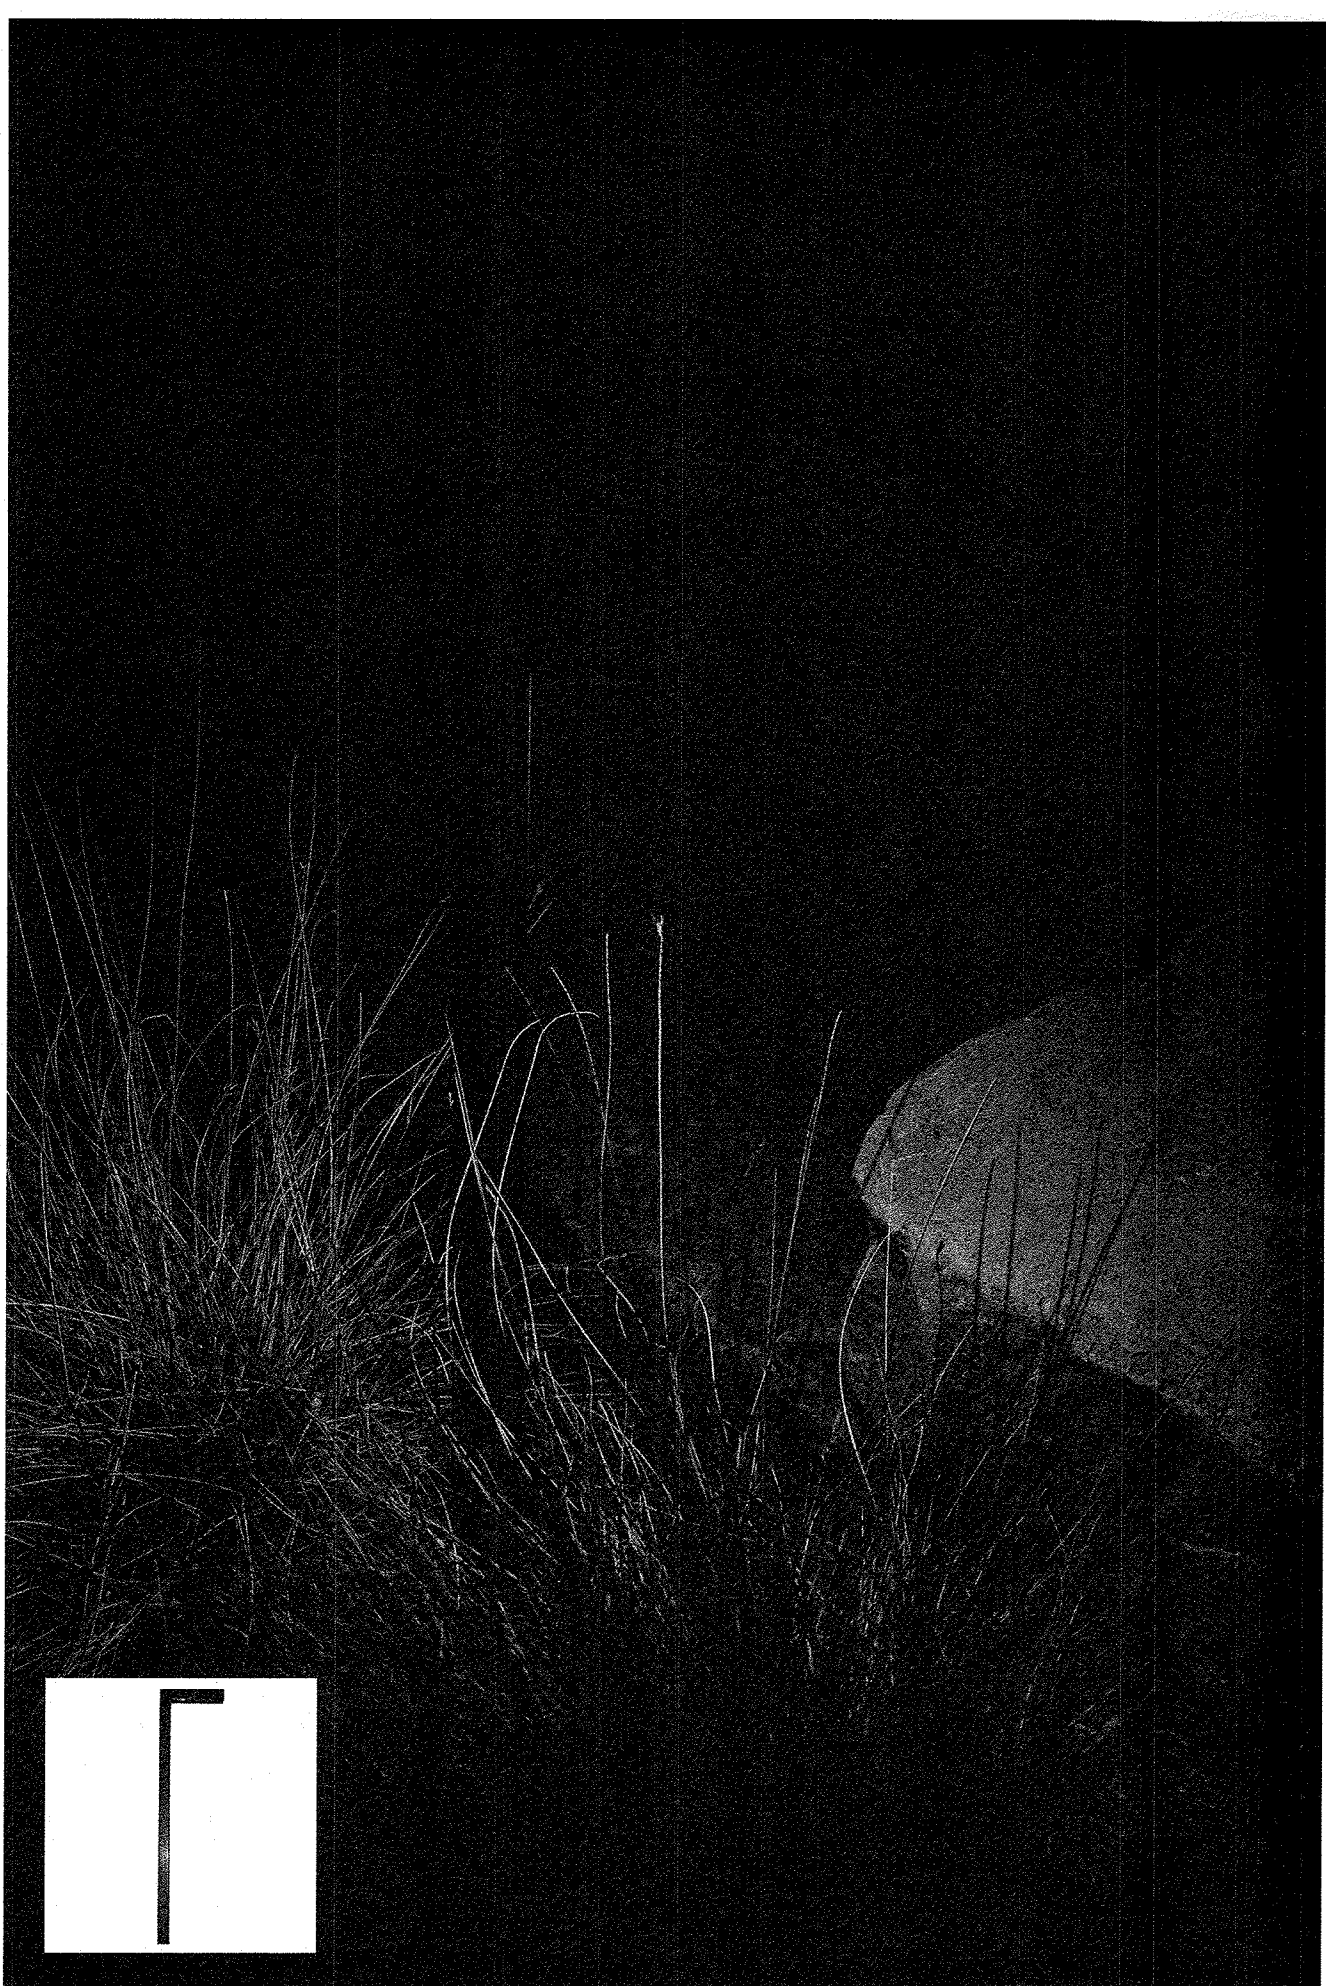

TYPE C PATH LIGHT, "L" STYLE

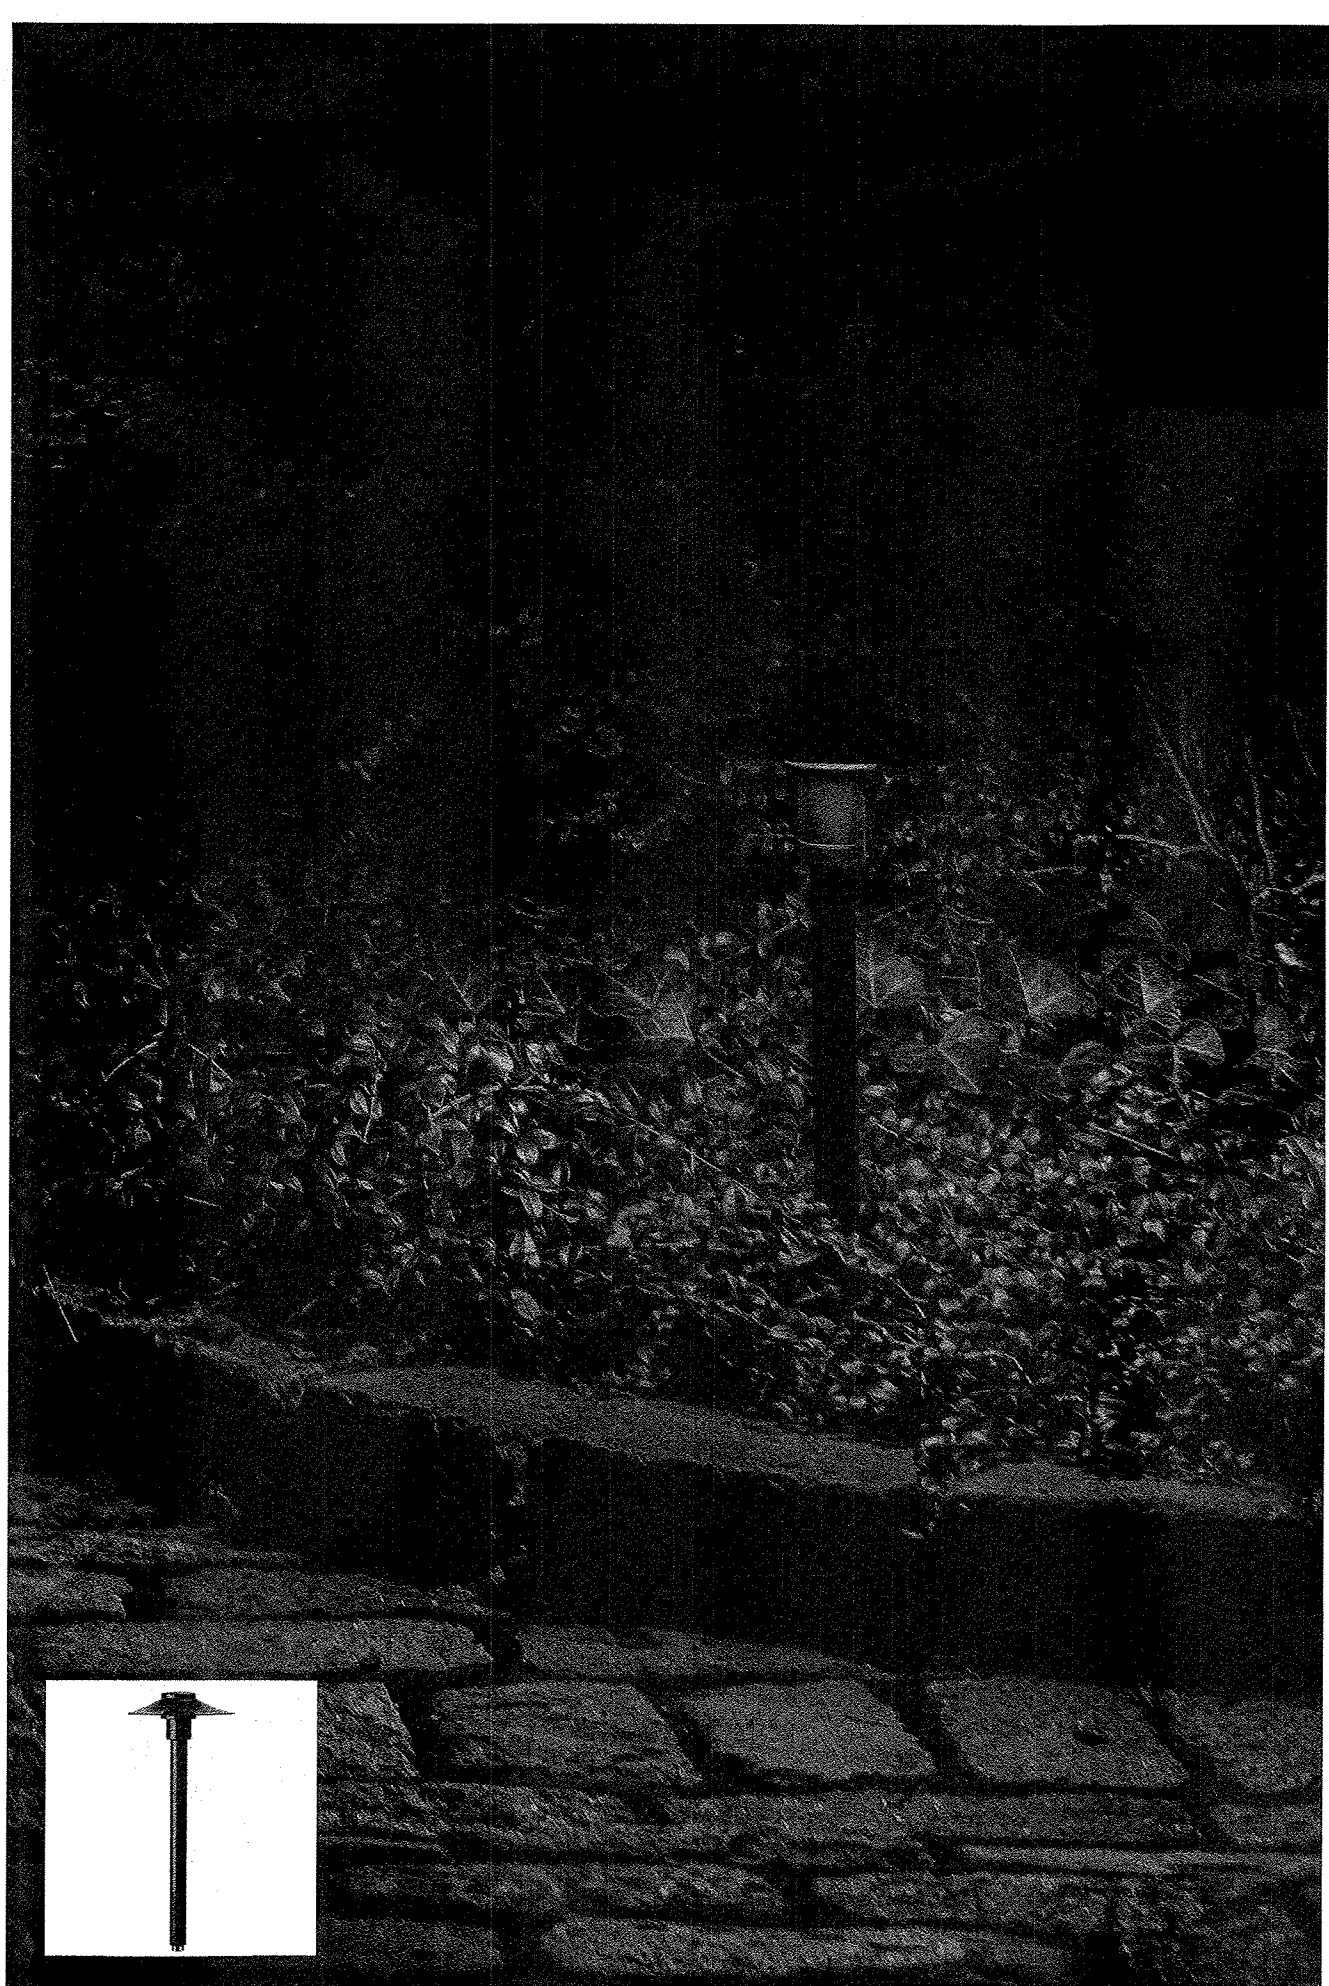

TYPE E PATH LIGHT, CIRCULAR STYLE



TYPE G STEP LIGHT, IN-WALL



TYPE J STRING LIGHTS



SCHEMATIC DESIGN
NOT FOR CONSTRUCTION