

NOTES

- LIGHTING BY ORSMAN DESIGN, INC. (ODI)
- FIXTURE GROUPING - TYPICAL
- FIXTURE GROUPING - PATH
- FIXTURE GROUPING - REMOTE DRIVER


LIGHT FIXTURE LEGEND

SYMBOL	TYPE	DESCRIPTION
▲	A	UPLIGHT, ADJUSTABLE HEIGHT
▼	B	DOWN LIGHT, TREE MOUNTED MR 16
└	C	PATH LIGHT, "L" STYLE
⊙	D	WELL LIGHT
⊕	E	PATH LIGHT, CIRCULAR STYLE
⊙	F	STAFF LIGHT
⊙	G	STEP LIGHT, IN-WALL
⊙	H	LINEAR LED, EXTERIOR RATED
⊙	J	STRING LIGHTS
⊕		TRANSFORMER
⊕		LINE VOLTAGE J BOX
⊕		LOW VOLTAGE J BOX
⊕		SPARE FEED
⊕		PVC SLEEVE BY OTHERS

DRAWING REVISIONS

NO.	DATE	DESCRIPTION
1	04.27.2021	S.D.

PROJECT	PRIVATE RESIDENCE 59 TWEED BLVD NYACK, NY
DWG TITLE	LANDSCAPE LIGHTING PLAN
DATE	04.26.2021
SCALE	3/32" = 1'-0"
SHEET NO.	LL-1.0

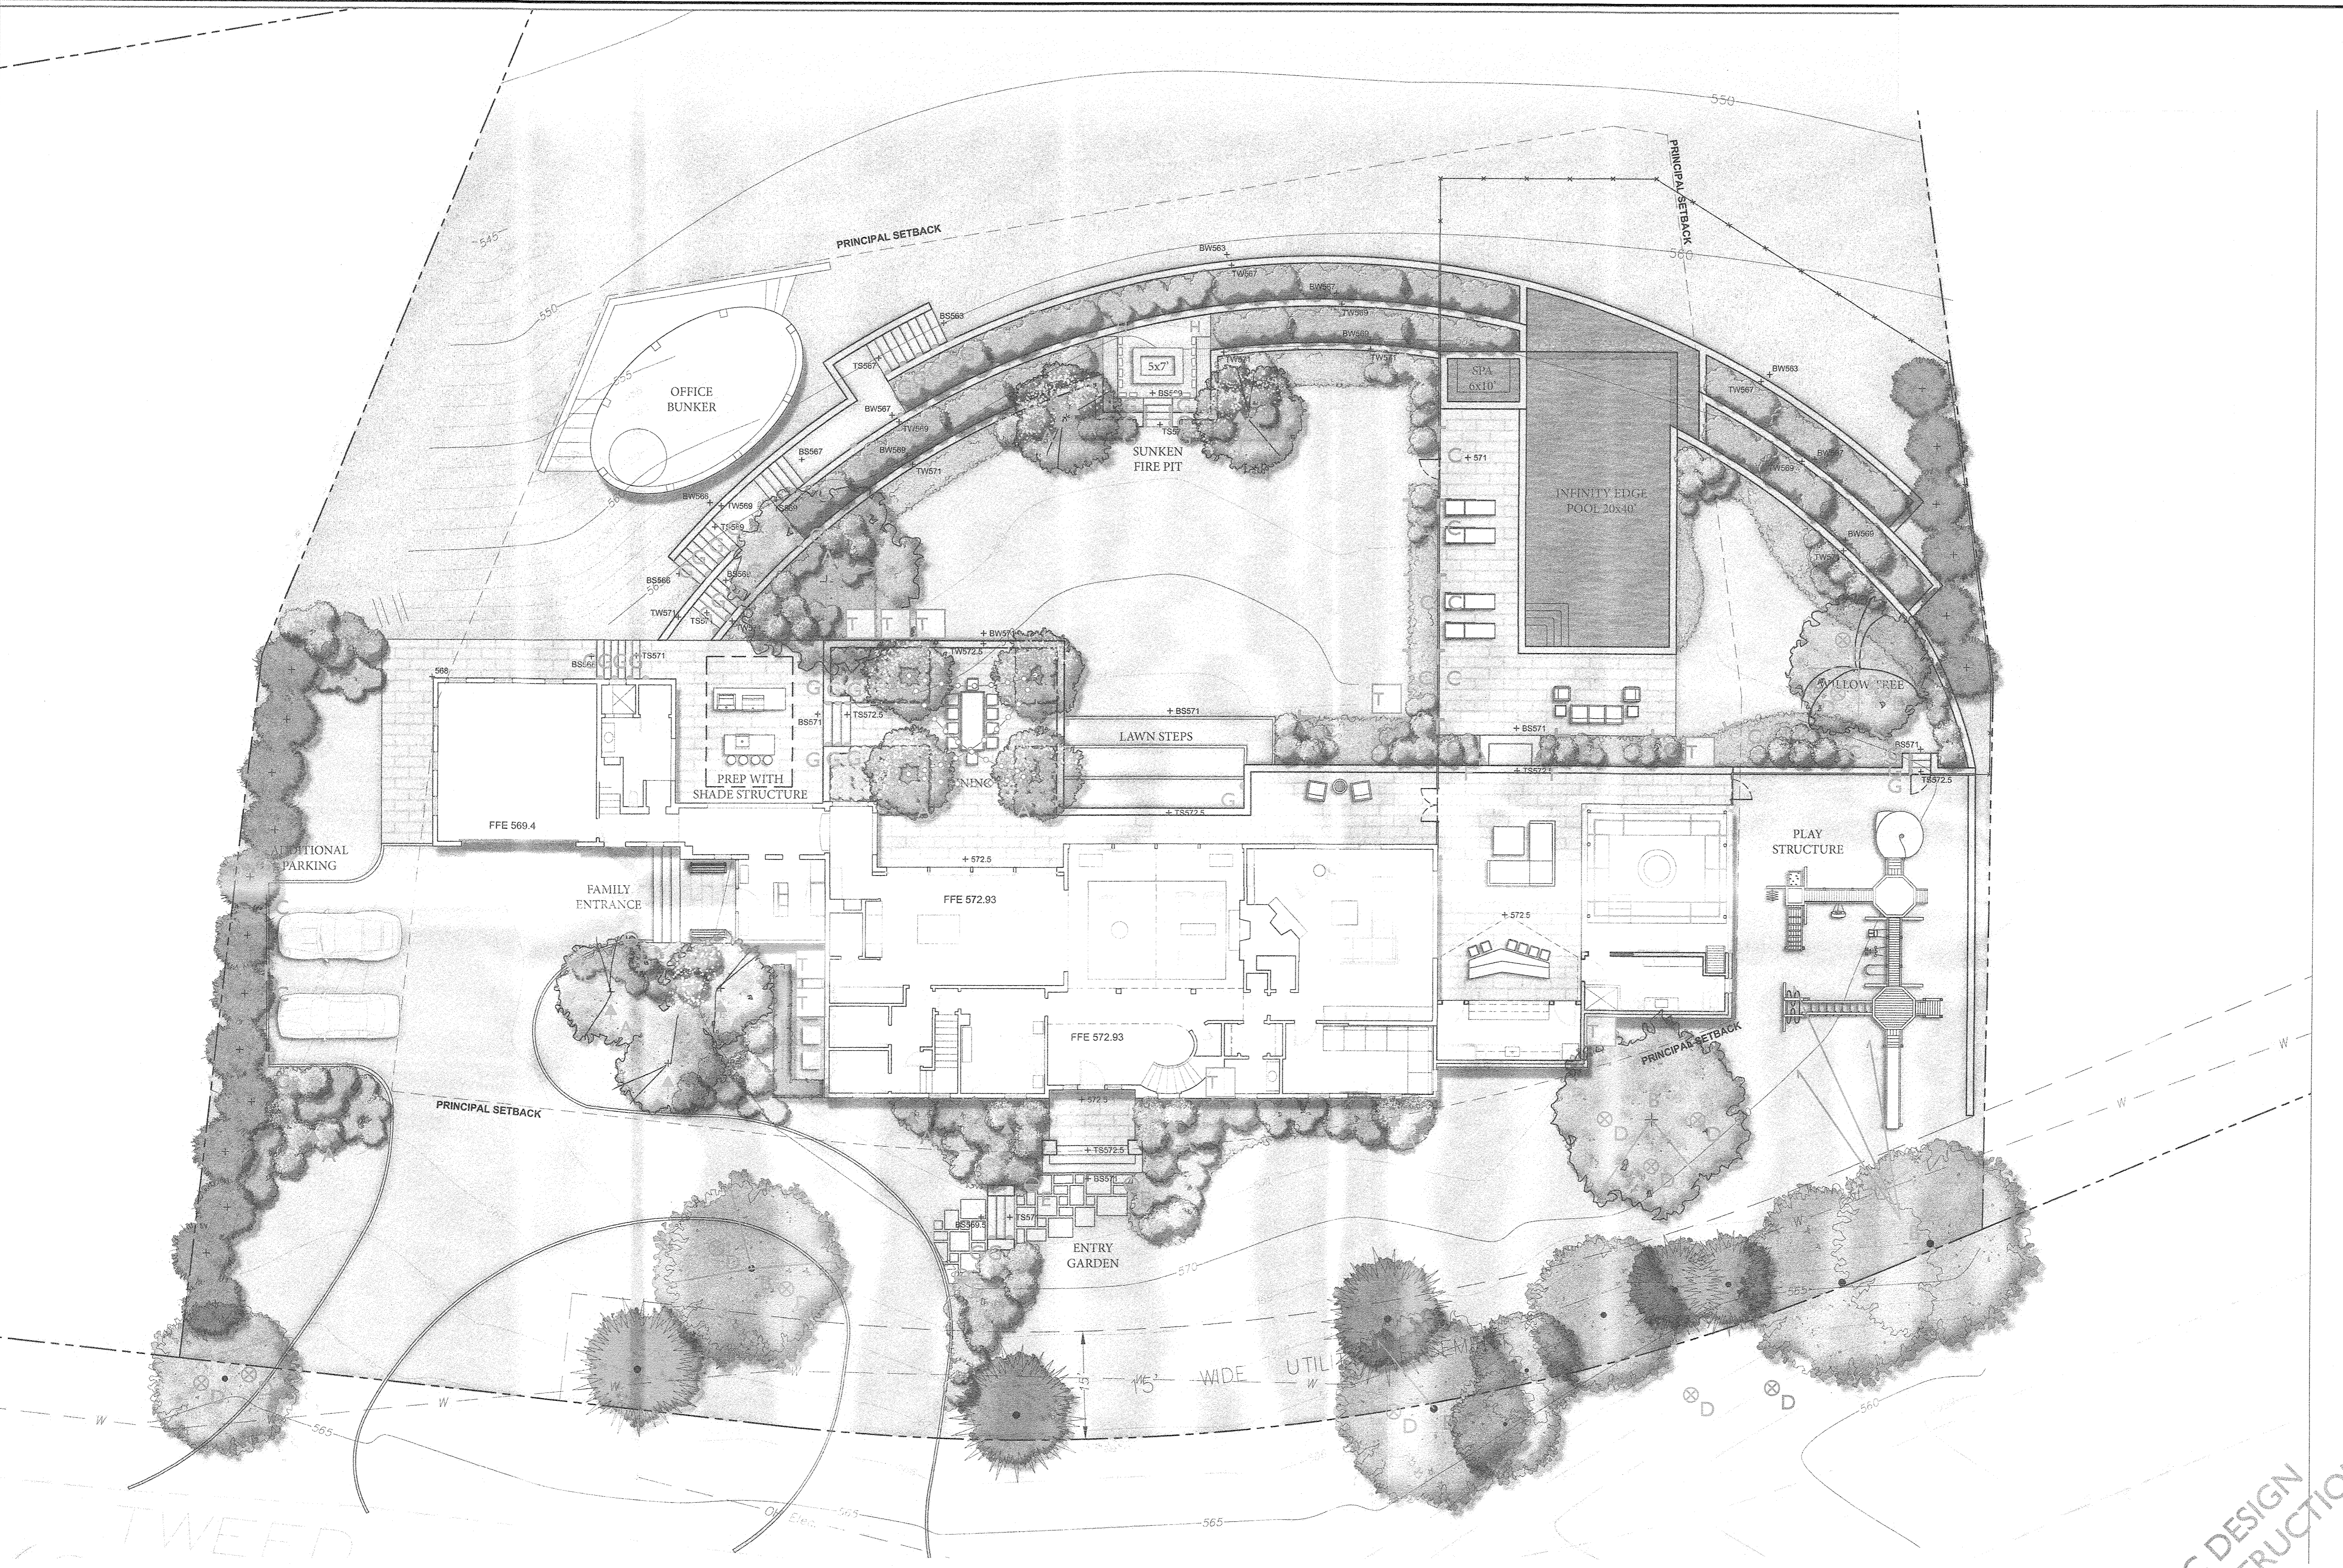

LANDSCAPE LIGHTING PLAN
3/32" = 1'-0"

SCHEMATIC DESIGN
NOT FOR CONSTRUCTION

NOTES

- LIGHTING BY ORSMAN DESIGN, INC. (ODI)
- FIXTURE GROUPING - TYPICAL
- FIXTURE GROUPING - PATH
- FIXTURE GROUPING - REMOTE DRIVER








LIGHT FIXTURE LEGEND

SYMBOL	TYPE	DESCRIPTION
▲	A	UPLIGHT, ADJUSTABLE HEIGHT
▼	B	DOWN LIGHT, TREE MOUNTED MR 16
—	C	PATH LIGHT, "L" STYLE
⊙	D	WELL LIGHT
⊙	E	PATH LIGHT, CIRCULAR STYLE
▲	F	STAFF LIGHT
▲	G	STEP LIGHT, IN-WALL
□	H	LINEAR LED, EXTERIOR RATED
—	J	STRING LIGHTS
⊞		TRANSFORMER
⊞		LINE VOLTAGE J BOX
⊞		LOW VOLTAGE J BOX
⊞		SPARE FEED
—		PVC SLEEVE BY OTHERS

DRAWING REVISIONS

1	04.27.2021 - S.D.
---	-------------------

PROJECT	PRIVATE RESIDENCE 59 TWEED BLVD NYACK, NY
DWG TITLE	LANDSCAPE LIGHTING CONCEPT IMAGERY
DATE	04.26.2021
SCALE	
SHEET NO.	LC-1.0

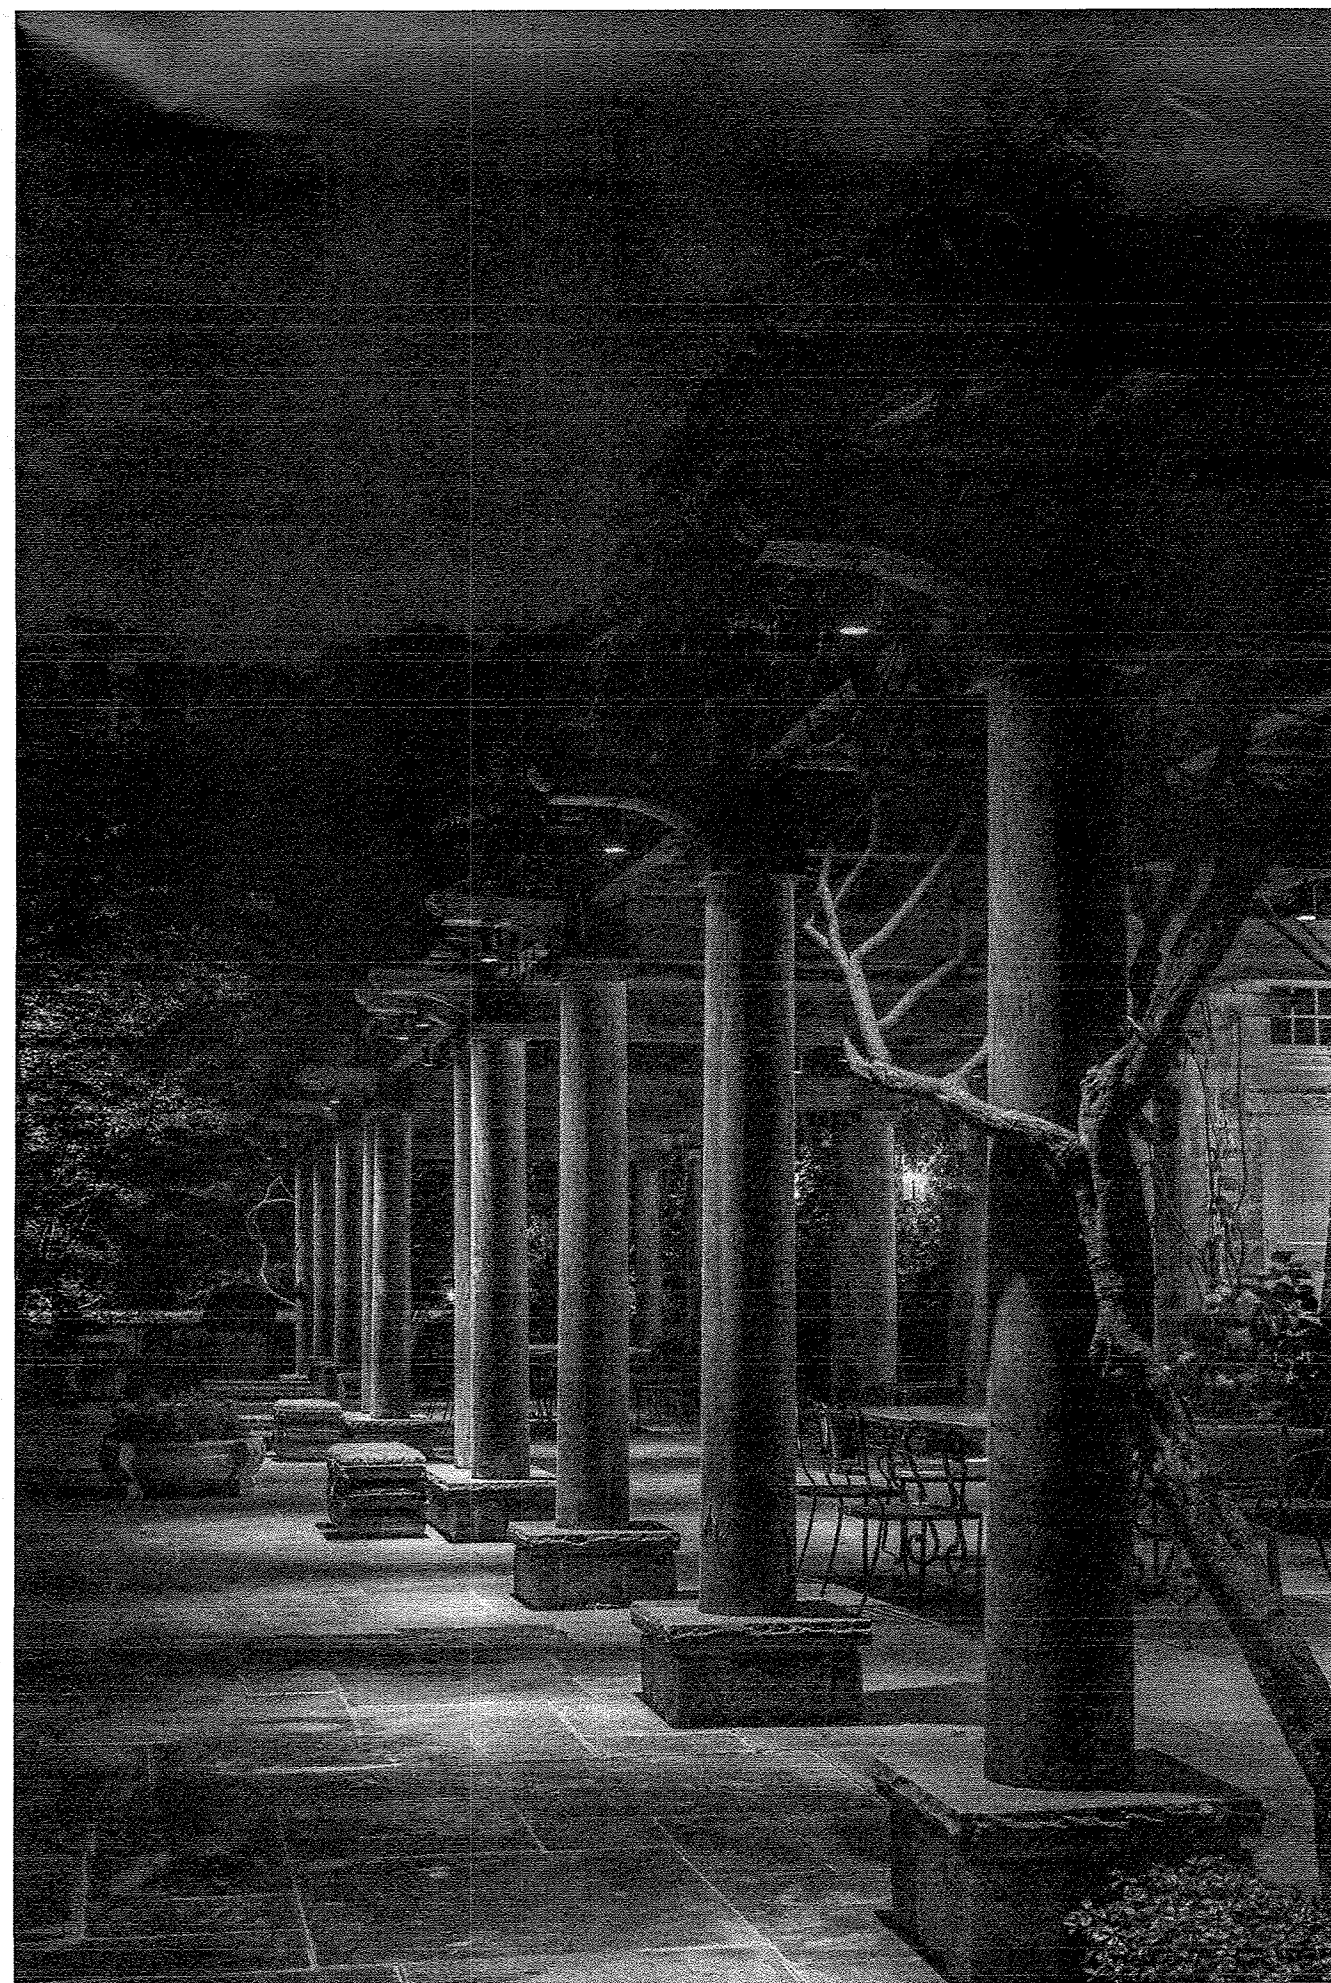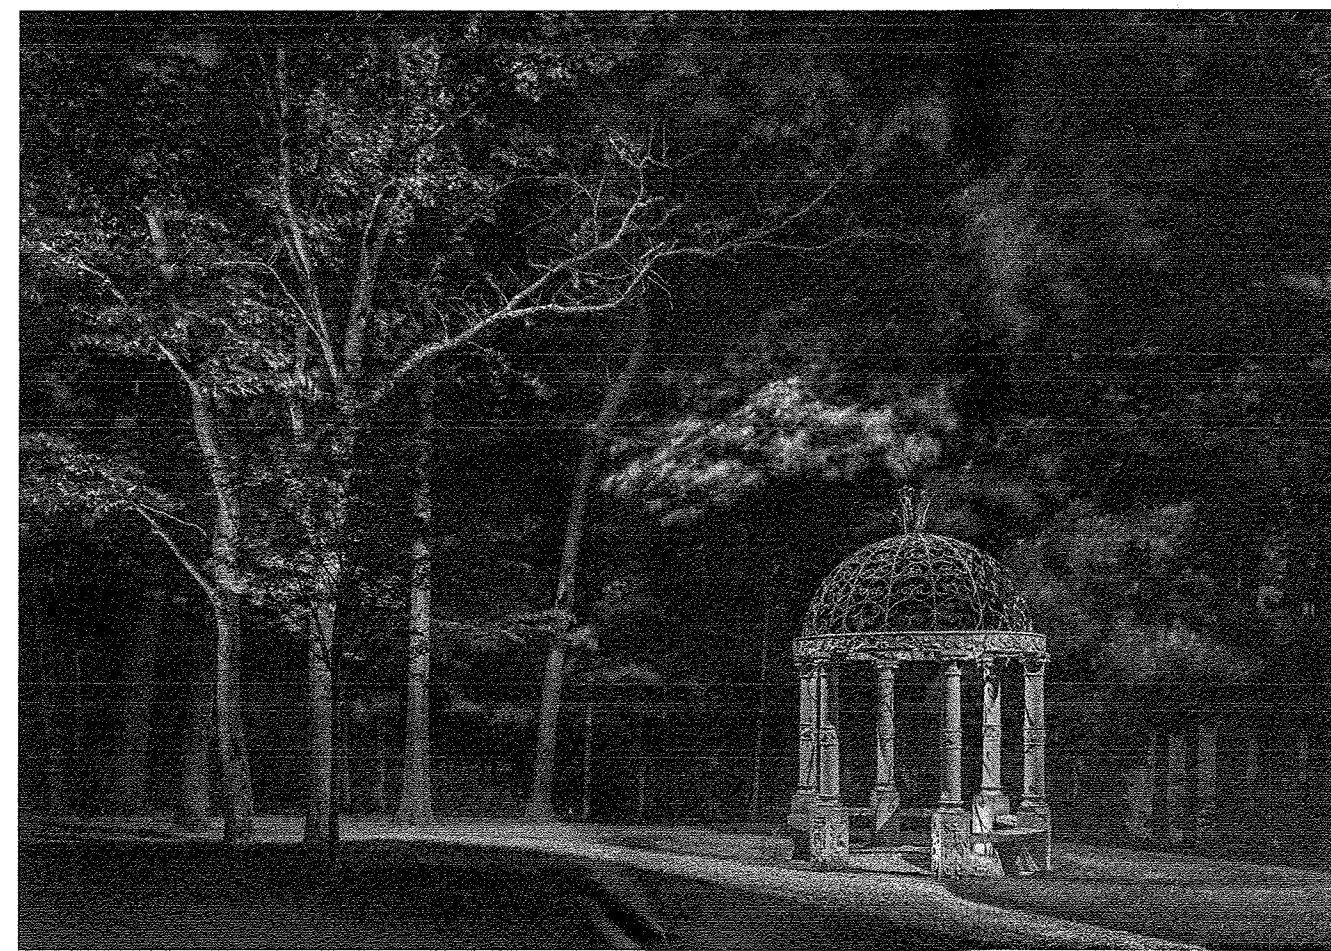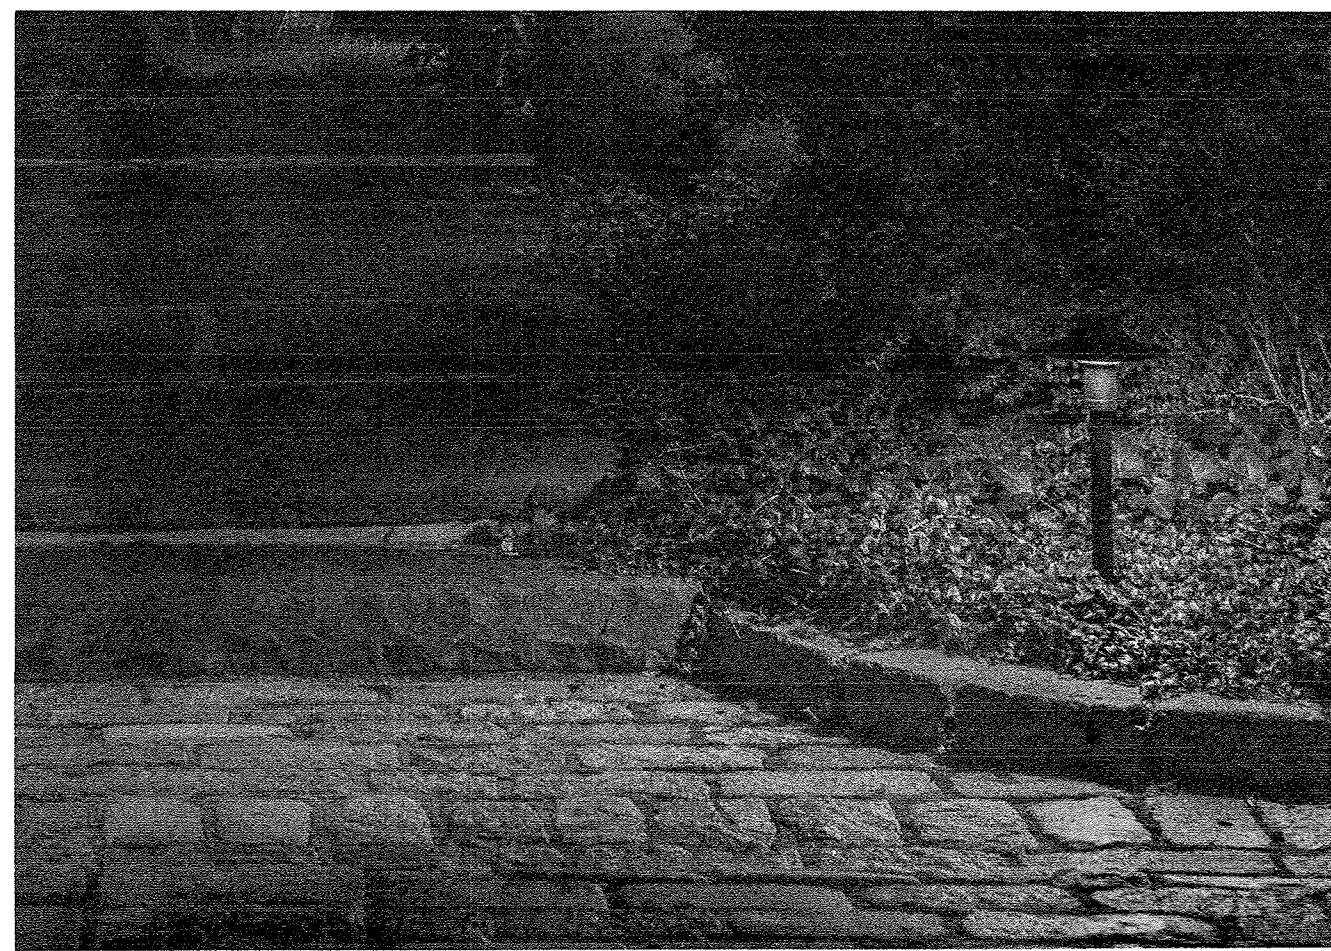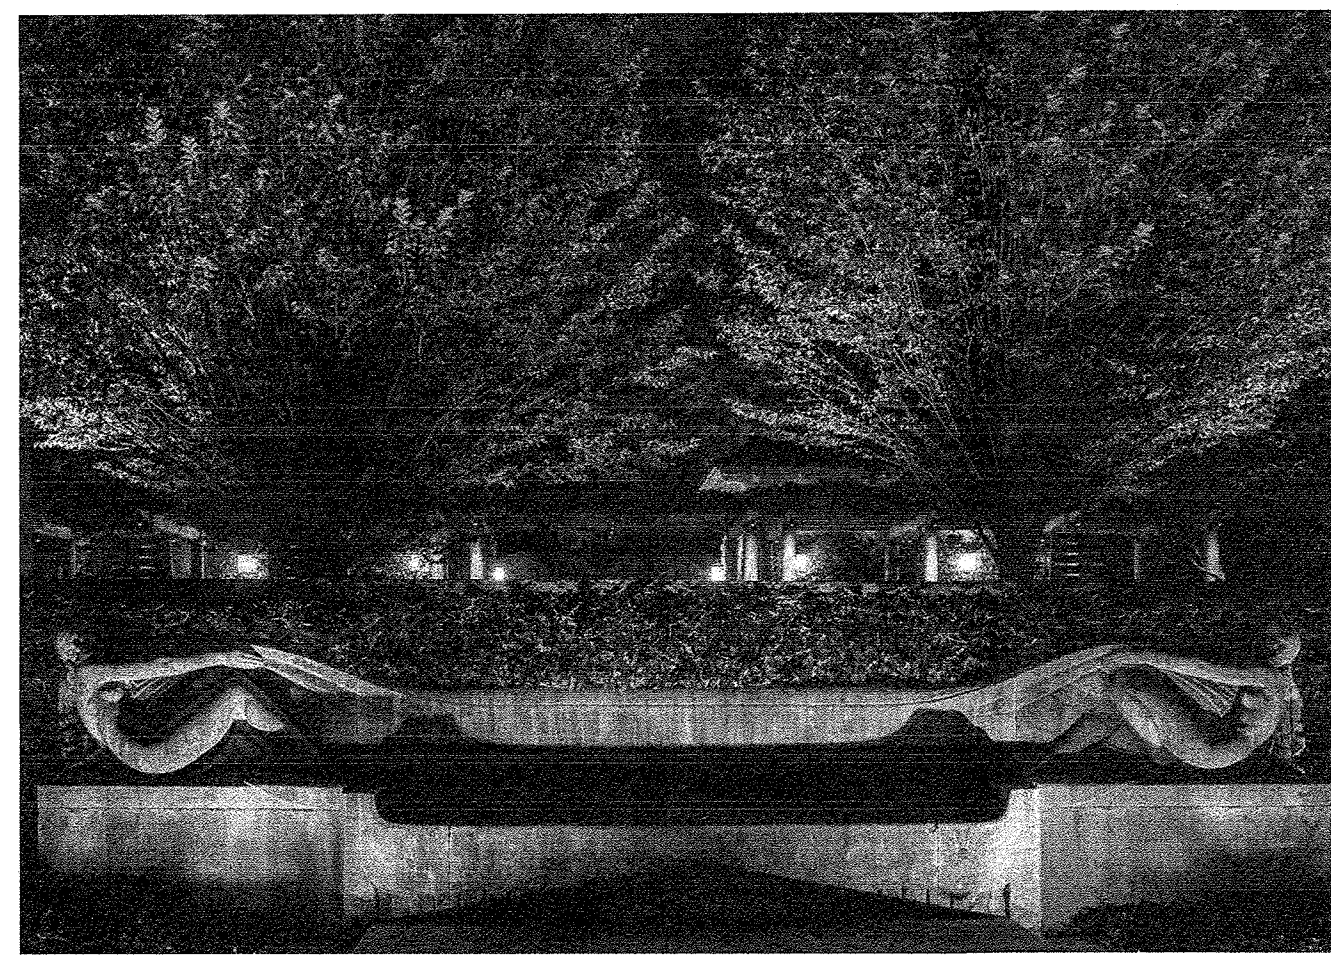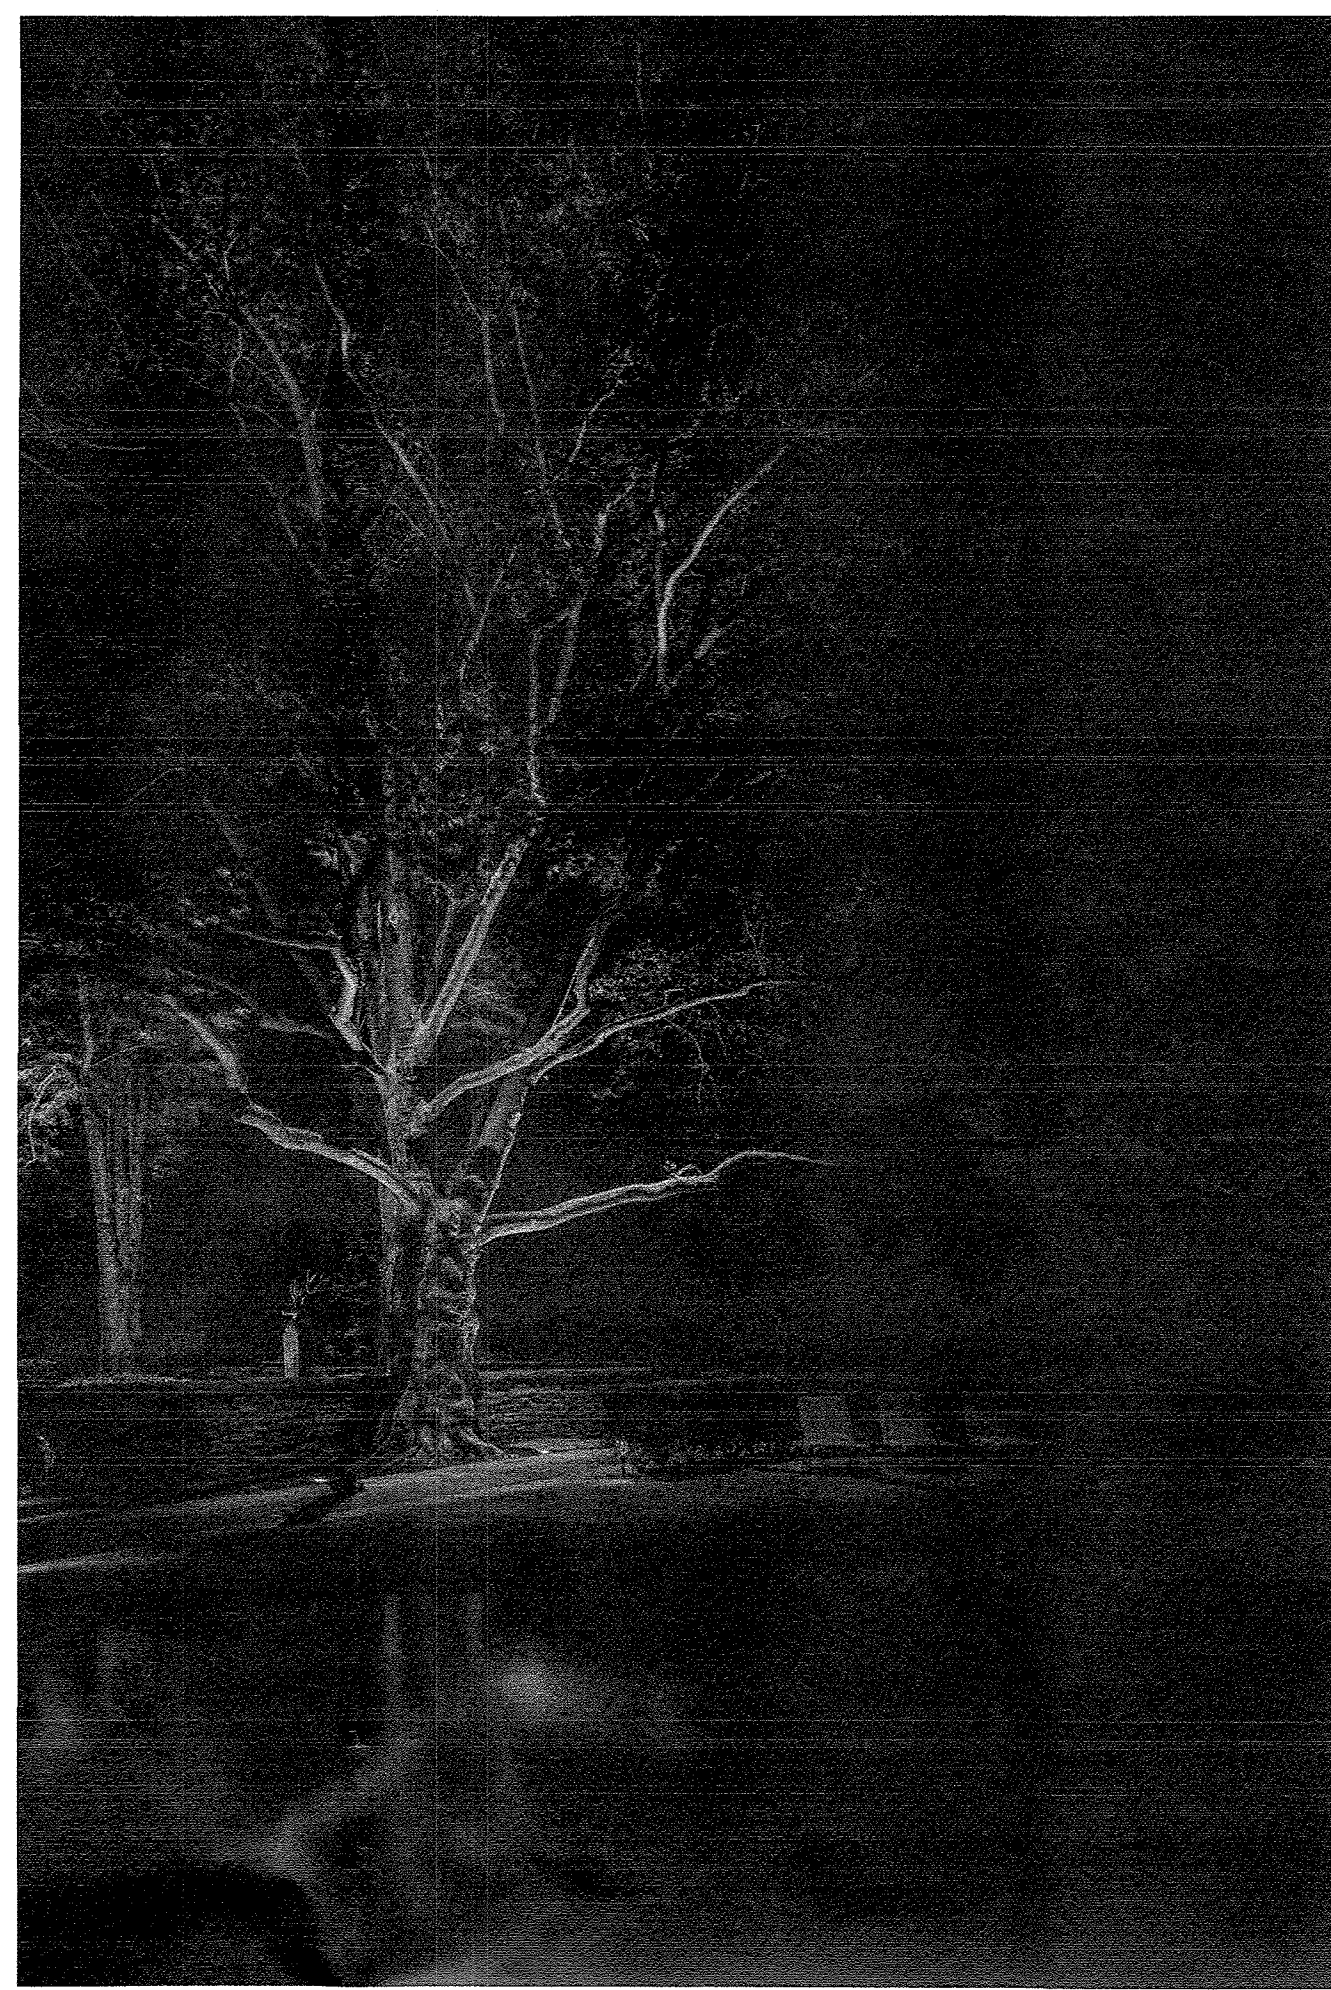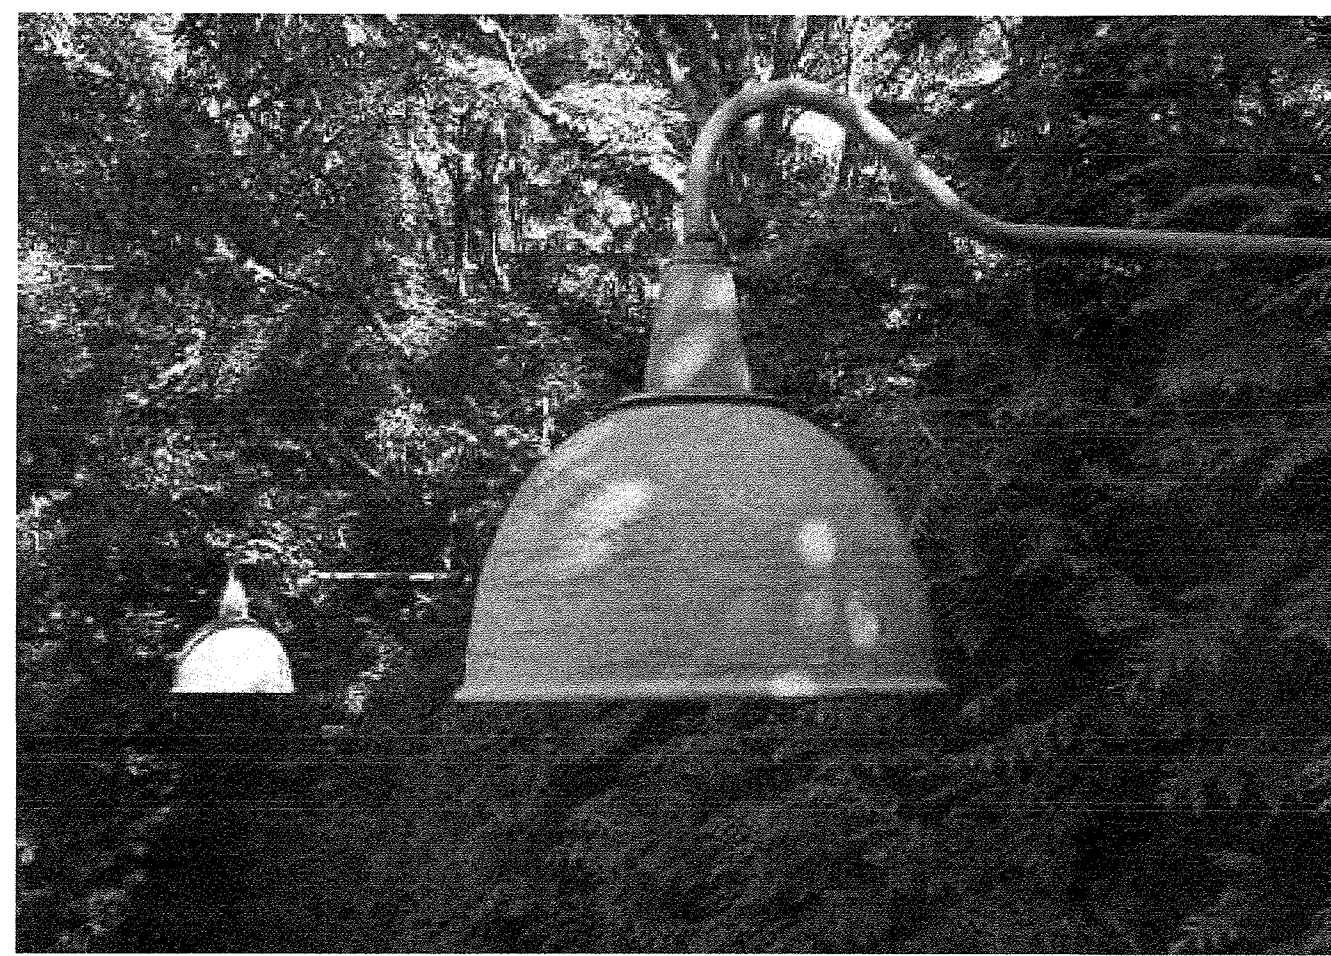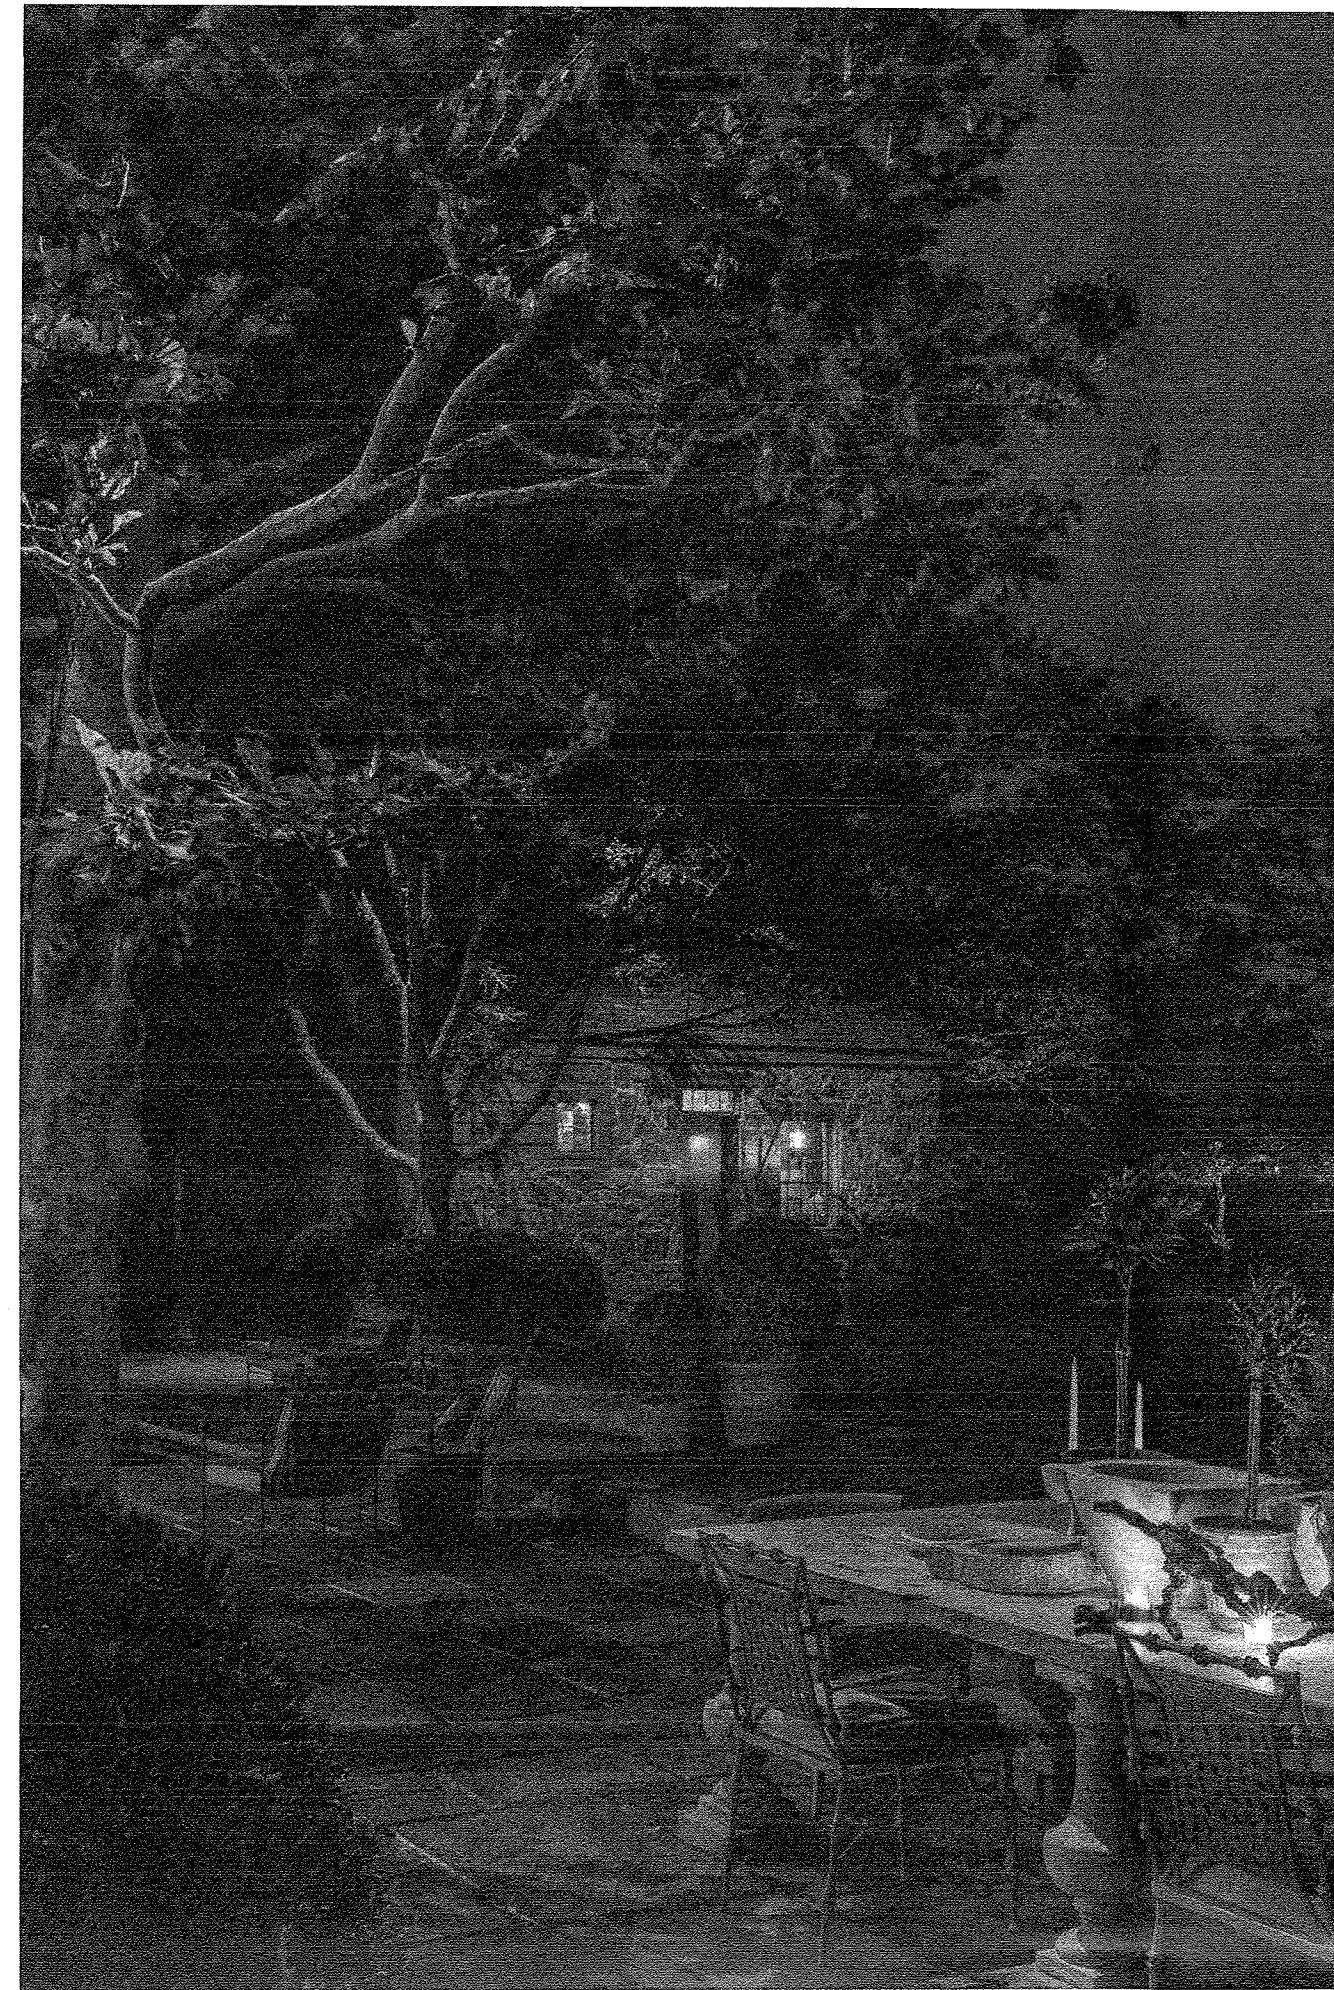

SCHEMATIC DESIGN
NOT FOR CONSTRUCTION

NOTES

- LIGHTING BY ORSMAN DESIGN, INC. (ODI)
- FIXTURE GROUPING - TYPICAL
- FIXTURE GROUPING - PATH
- FIXTURE GROUPING - REMOTE DRIVER

LIGHT FIXTURE LEGEND



SYMBOL	TYPE	DESCRIPTION
	A	UPLIGHT, ADJUSTABLE HEIGHT
	B	DOWN LIGHT, TREE MOUNTED MR 16
	C	PATH LIGHT, "L" STYLE
	D	WELL LIGHT
	E	PATH LIGHT, CIRCULAR STYLE
	F	STAFF LIGHT
	G	STEP LIGHT, IN-WALL
	H	LINEAR LED, EXTERIOR RATED
	J	STRING LIGHTS

	TRANSFORMER
	LINE VOLTAGE J BOX
	LOW VOLTAGE J BOX
	SPARE FEED
	PVC SLEEVE BY OTHERS



DRAWING REVISIONS

I	04.27.2021 - S.D.
---	-------------------



PROJECT	PRIVATE RESIDENCE 59 TWEED BLVD NYACK, NY
DWG TITLE	LANDSCAPE LIGHTING CONCEPT IMAGERY
DATE	04.26.2021
SCALE	
SHEET NO.	LC-1.2

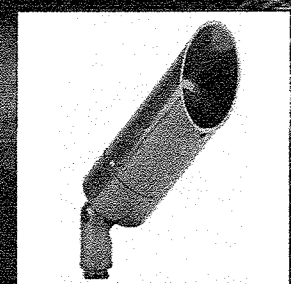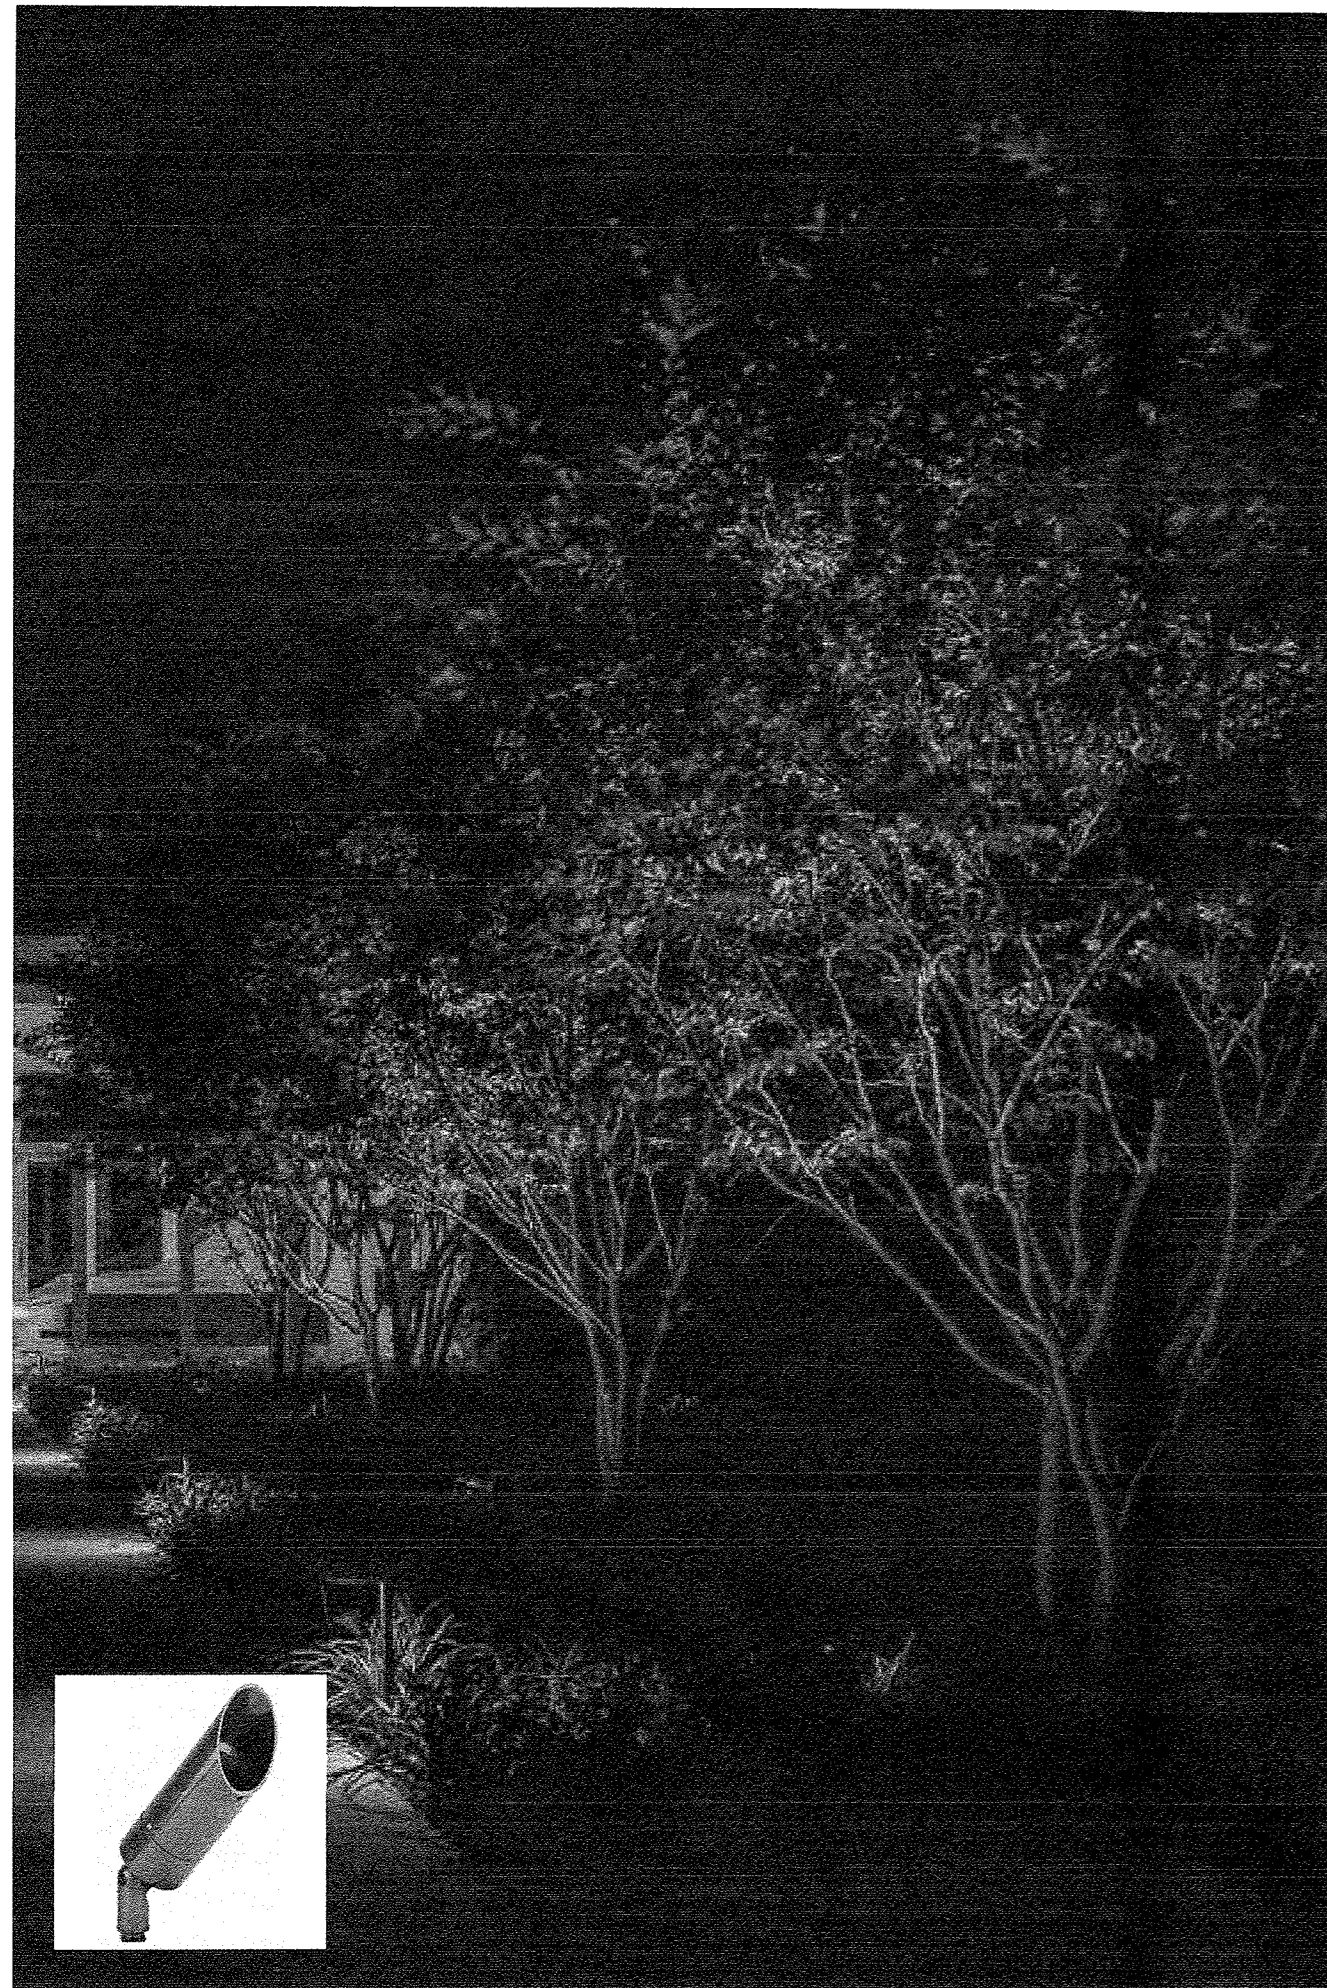



↑ TYPE A/B UPLIGHT/DOWNLIGHT

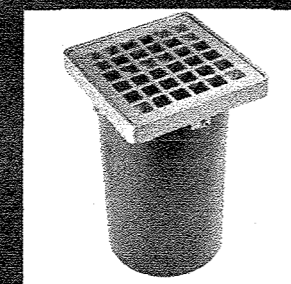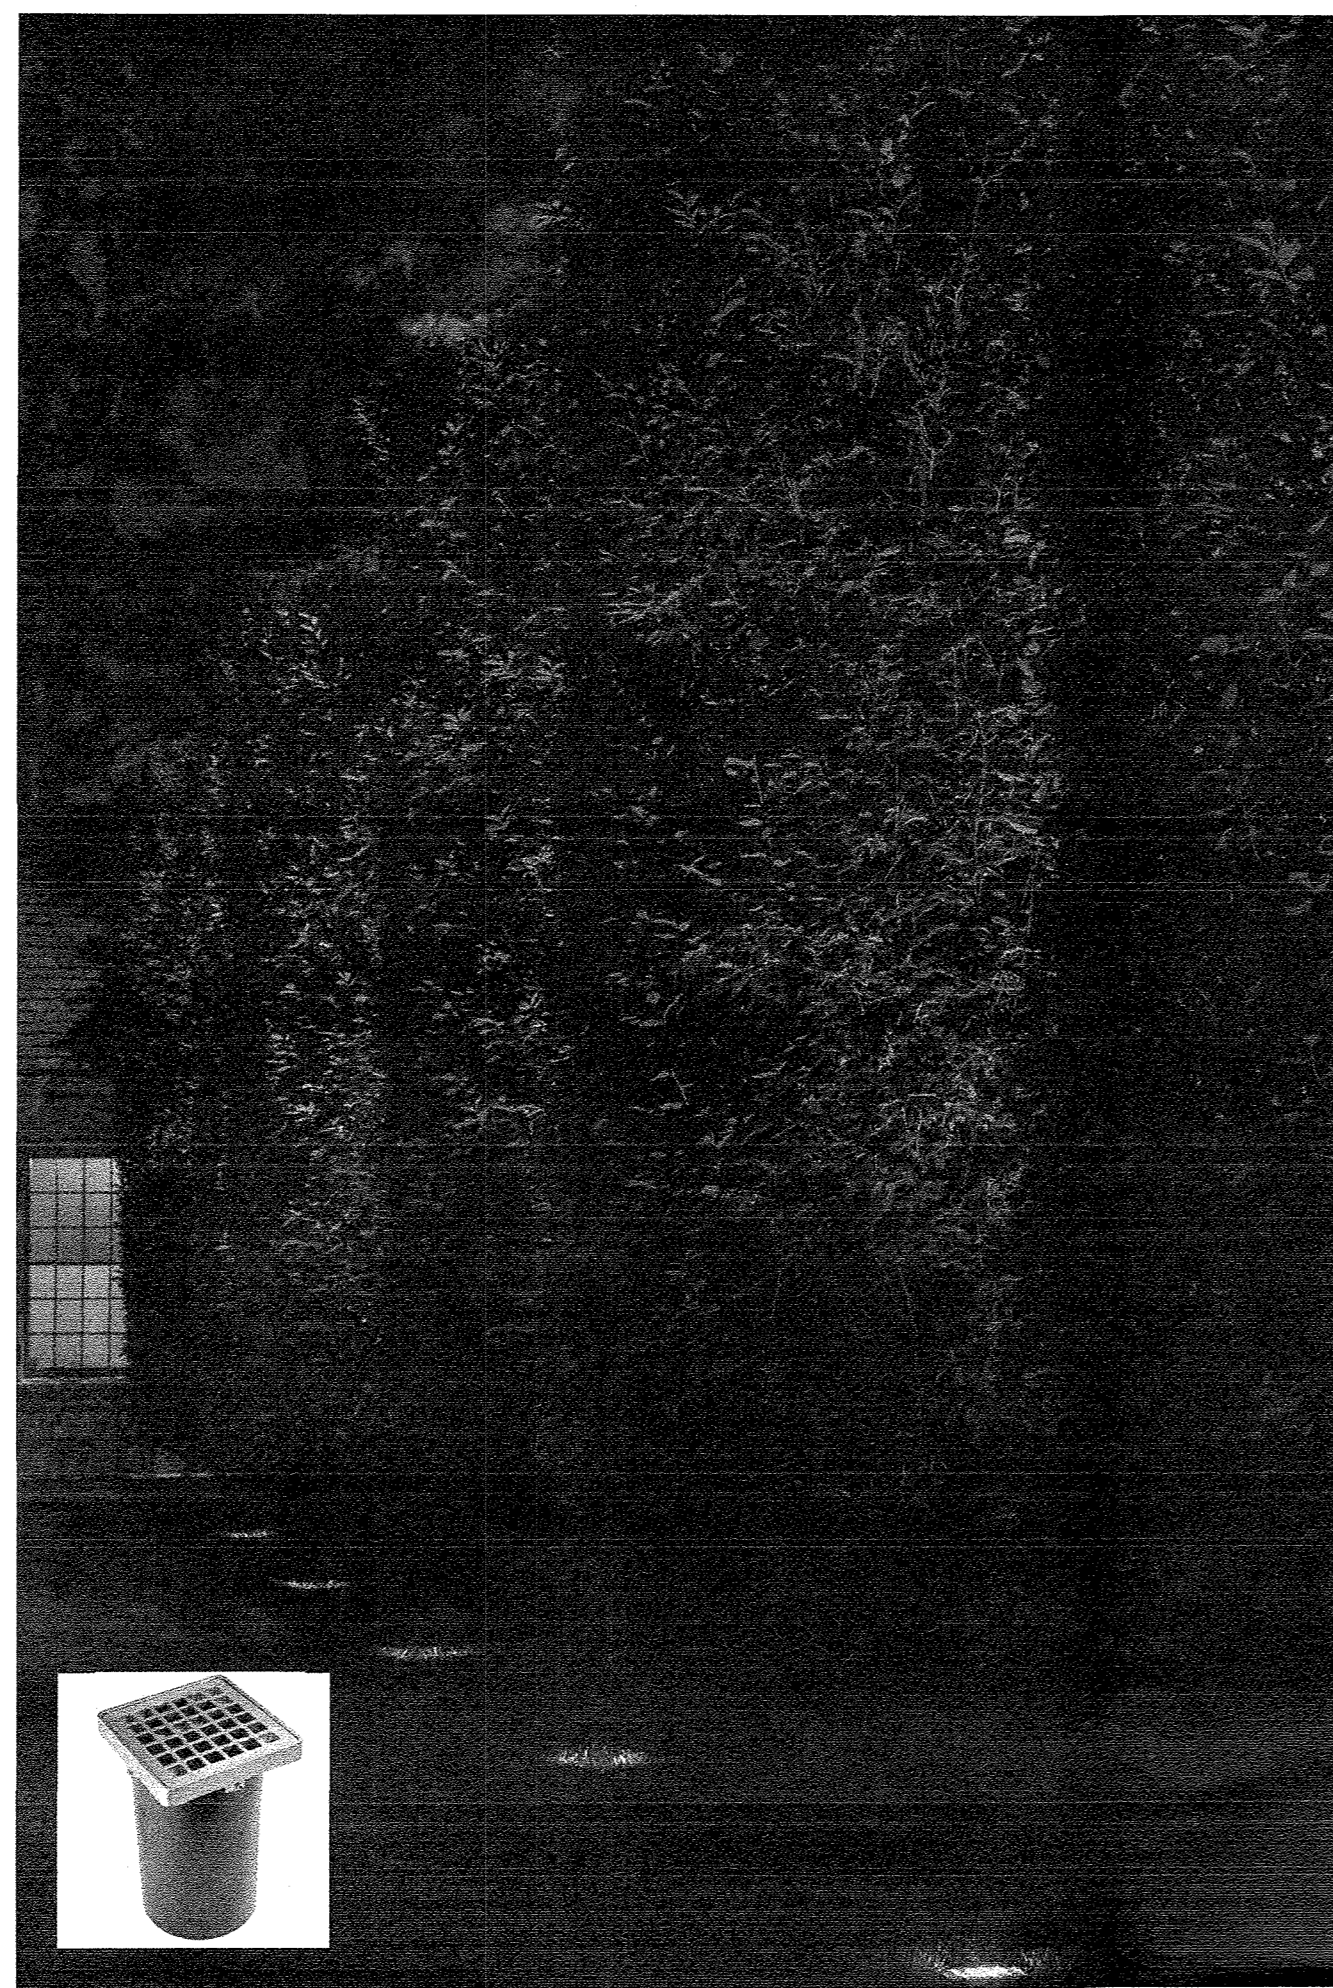


⊗ TYPE D WELL LIGHT

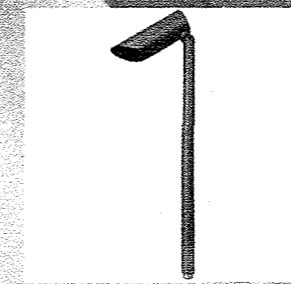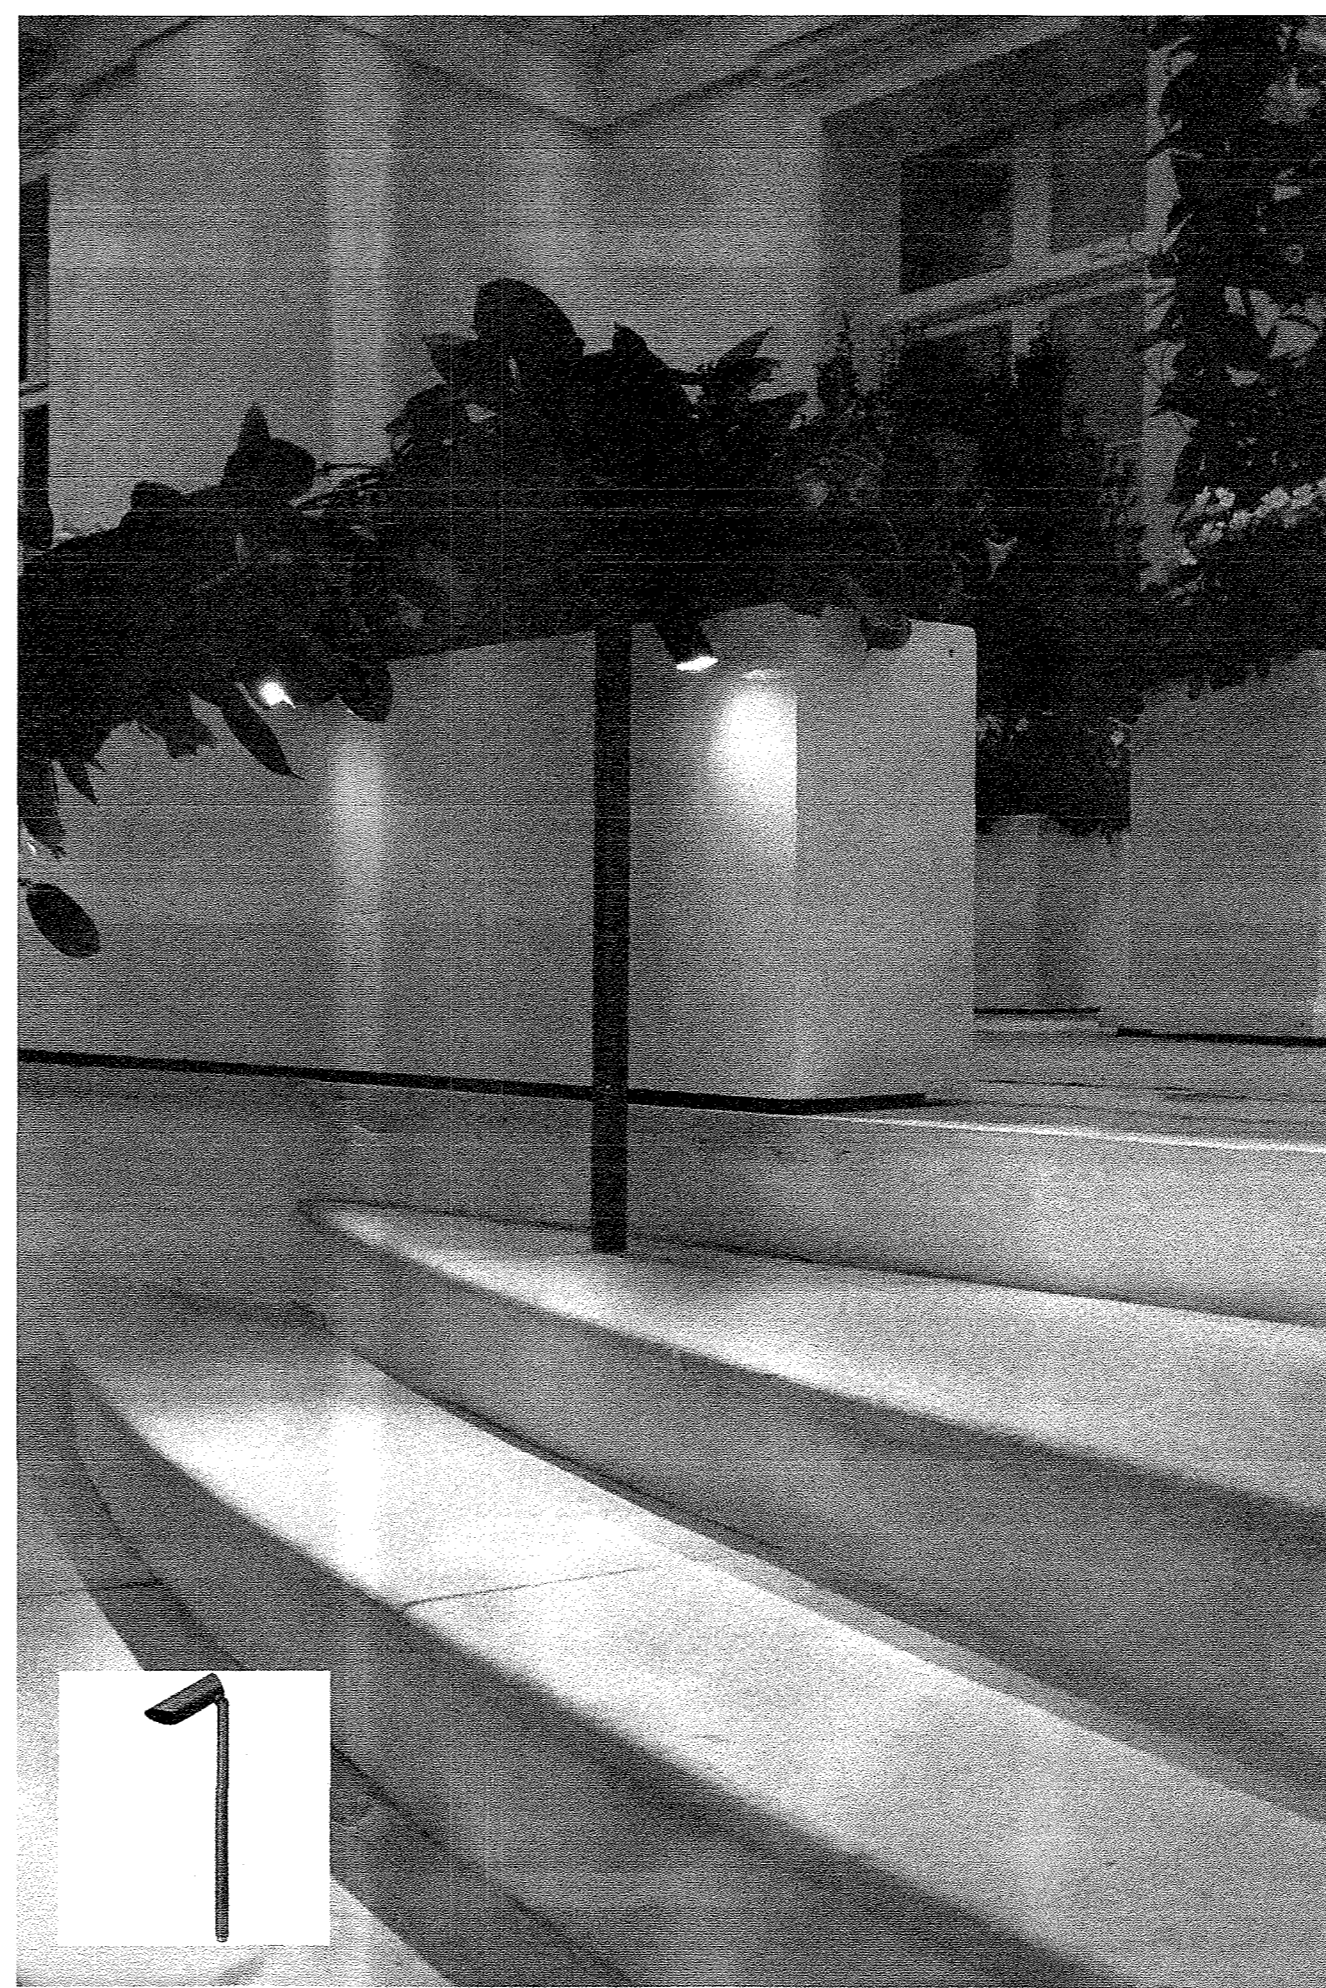


↑ TYPE F STAFF LIGHT

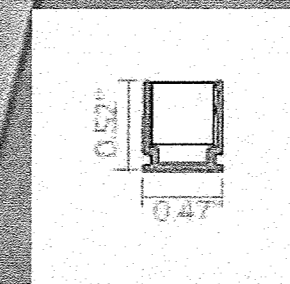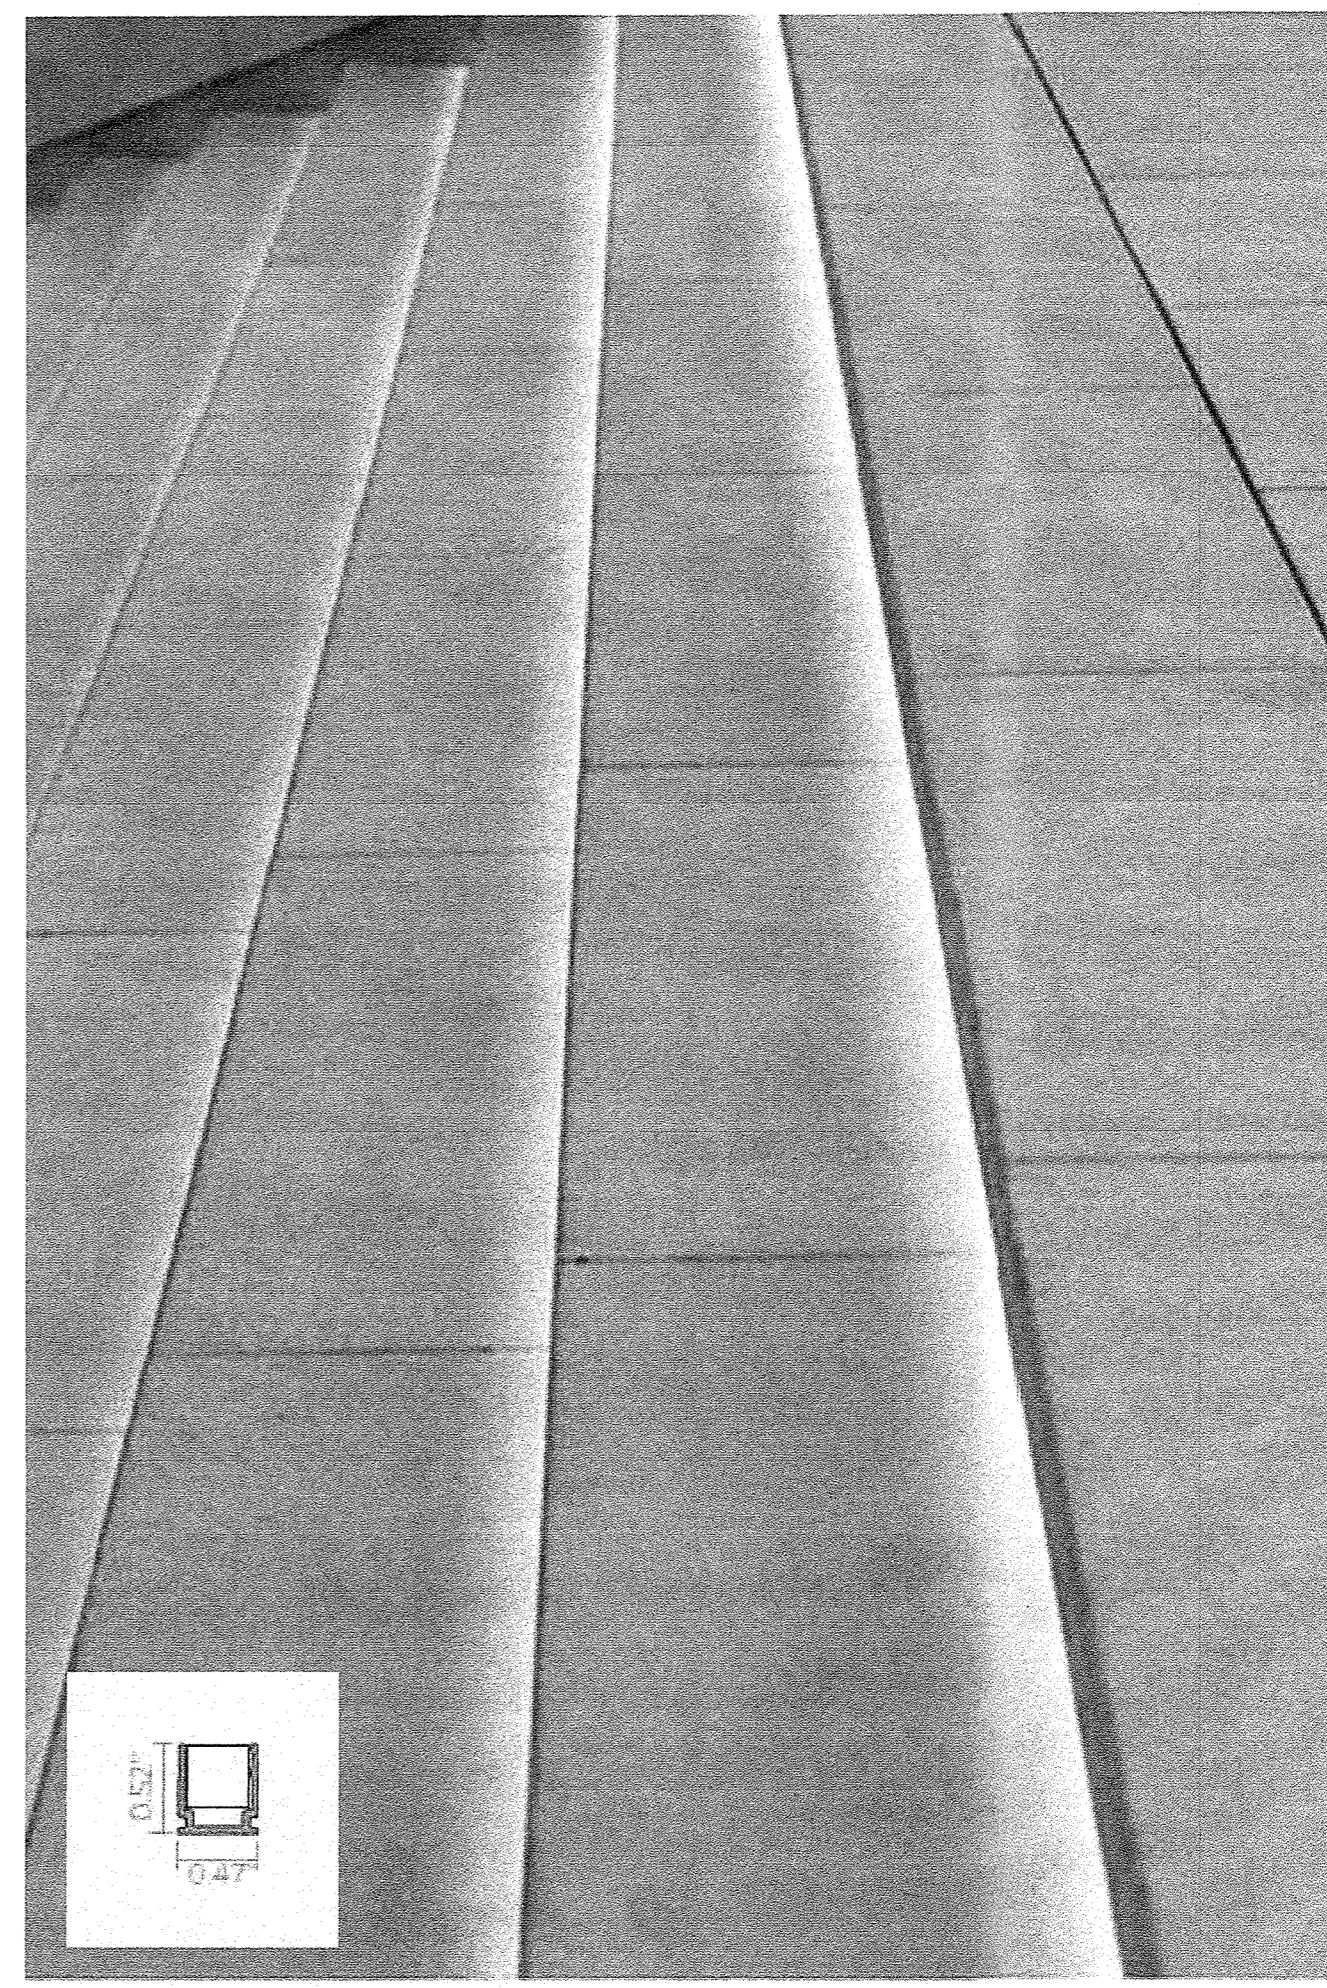



□□□□ TYPE H LINEAR LED, EXTERIOR-RATED

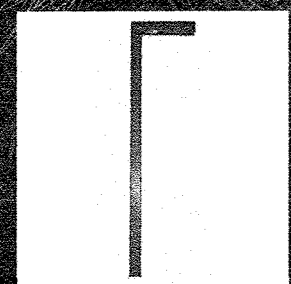


└ TYPE C PATH LIGHT, "L" STYLE

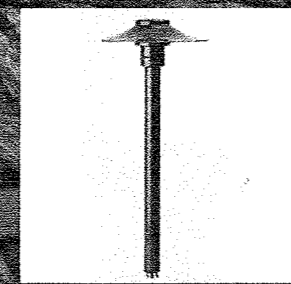

⊙ TYPE E PATH LIGHT, CIRCULAR STYLE

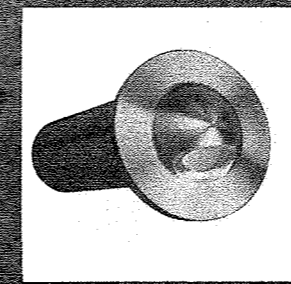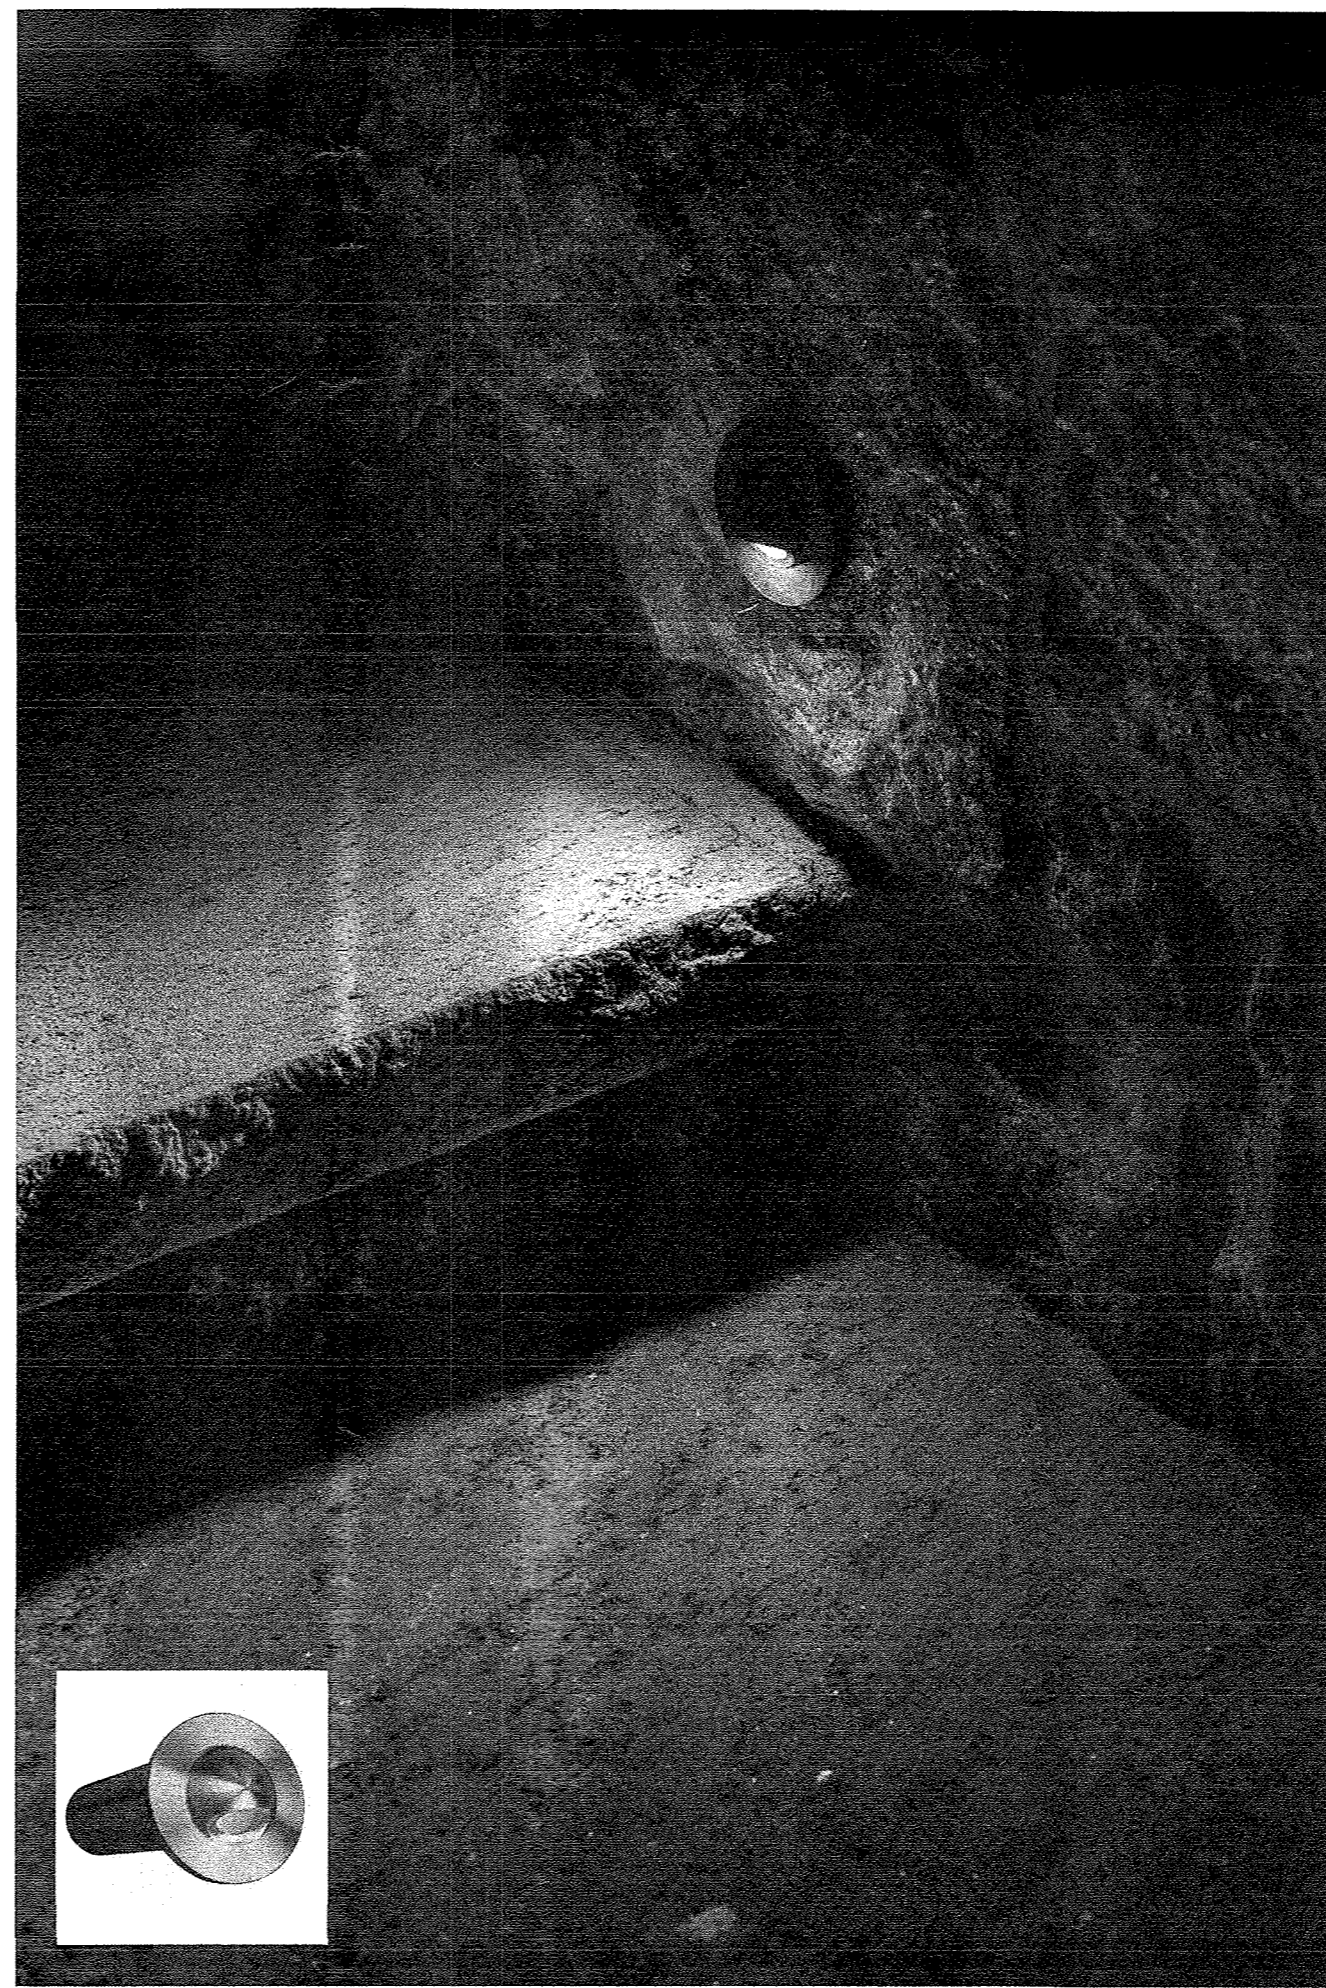

◐ TYPE G STEP LIGHT, IN-WALL

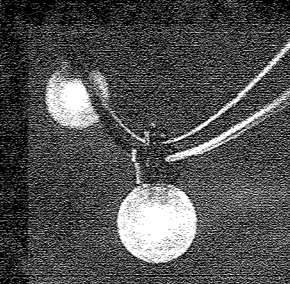

—●—●—●— TYPE J STRING LIGHTS

SCHEMATIC DESIGN
NOT FOR CONSTRUCTION