


TURNING TEMPLATE


SCALE: 1" = 20'

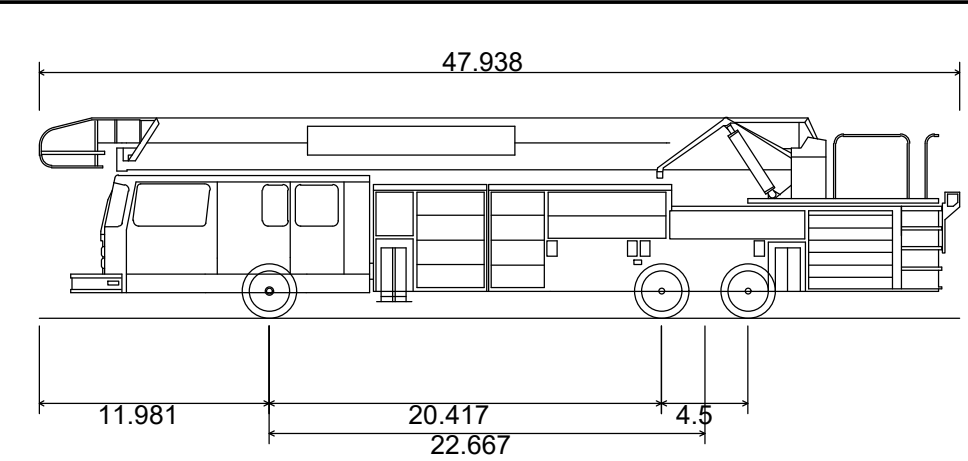

Orangetown Firetruck	
Overall Length	47.938ft
Overall Width	8.000ft
Overall Body Height	10.432ft
Min Body Ground Clearance	0.862ft
Track Width	8.000ft
Lock-to-lock time	6.00s
Curb to Curb Turning Radius	33.210ft

VEHICLE PROFILE

SCALE: 1" = 10'

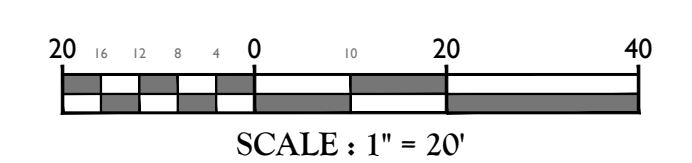

SCALE: 1" = 20'

Jesse Barrett Cokeley  
NEW YORK LICENSED PROFESSIONAL ENGINEER  
LICENSE NUMBER: 090987-01  
COLLIERS ENGINEERING & DESIGN CT, P.C.  
N.Y. C.O.A.#: 0017669

FINAL SITE PLAN  
FOR  
RRIS CORPORATION

SECTION 74.11  
BLOCK 2  
LOT 26  
TOWN OF ORANGETOWN  
ROCKLAND COUNTY  
NEW YORK

**Colliers**  
Engineering & Design  
WOODCLIFF LAKE  
300 Tice Boulevard  
Suite 101  
Woodcliff Lake, NJ 07677  
Phone: 845.352.0411  
COLLIERS ENGINEERING & DESIGN, INC. DOING BUSINESS AS MASER CONSULTING

SCALE:	DATE:	DRAWN BY:	CHECKED BY:
AS SHOWN	2/20/24	NJ	JBC
PROJECT NUMBER:	DRAWING NAME:		
15002742A	C-LAY1		

SHEET TITLE  
FIRE TRUCK MOVEMENT EXHIBIT

SHEET NUMBER  
1 of 1