



SUR/FOR:

**DIONNES WAY**  
 PEARL RIVER, NY 10965

DATE: OCTOBER 15, 2018  
 DRAWN BY: ZJS  
 JOB NO: 101118  
 SCALE: 1" = 10'  
 FILENAME: 2020\_0924  
 Dionnes Way

REVISIONS:




**LIGHTING PLAN**

SHEET NO.

**L-601**


SHEET: 1 of 2

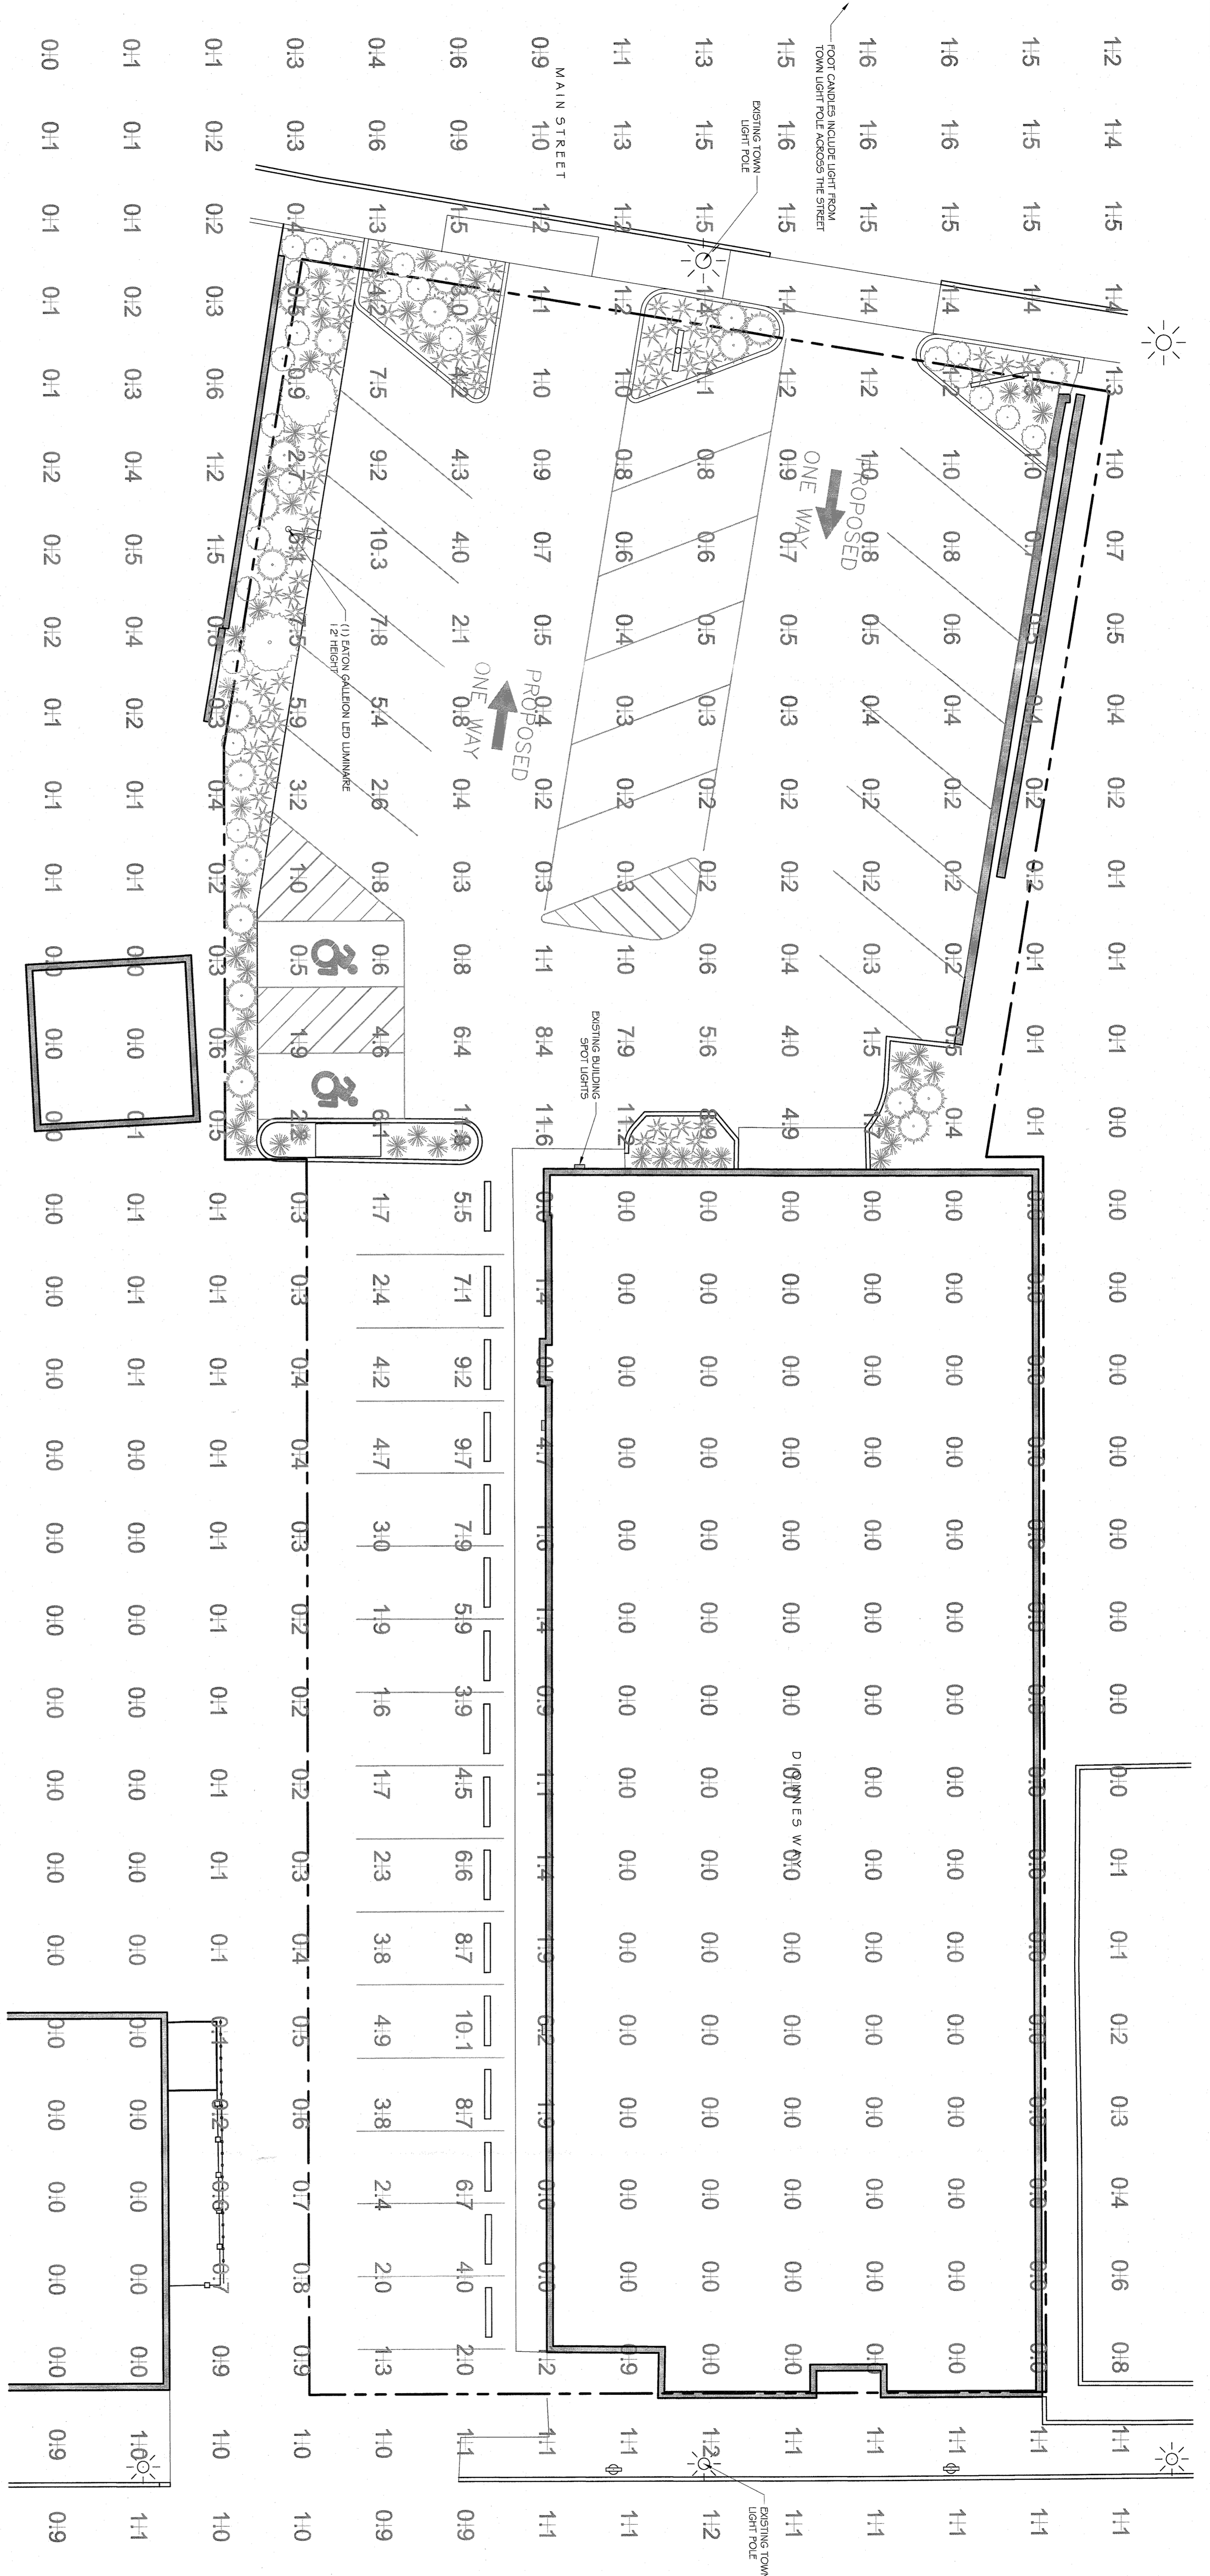

**■ LIGHTING SCHEDULE**

SYMBOL	DETAIL	QTY	DESCRIPTION	CATALOG NUMBER	MOUNTING HEIGHT	LAMP	LUMENS
□	L-601	1	EATON GALILEON LED LUMINAIRE POLE MOUNTED 5 LED LIGHT SQUARES TYPE 12 DISTRIBUTION	GLEON-MF-Q2-LED-E-12	12'	LED ARRAY	19,045+

NOTE: FOOT CANDLES INCLUDE STREET LIGHTS AND EXISTING BUILDING LIGHTS

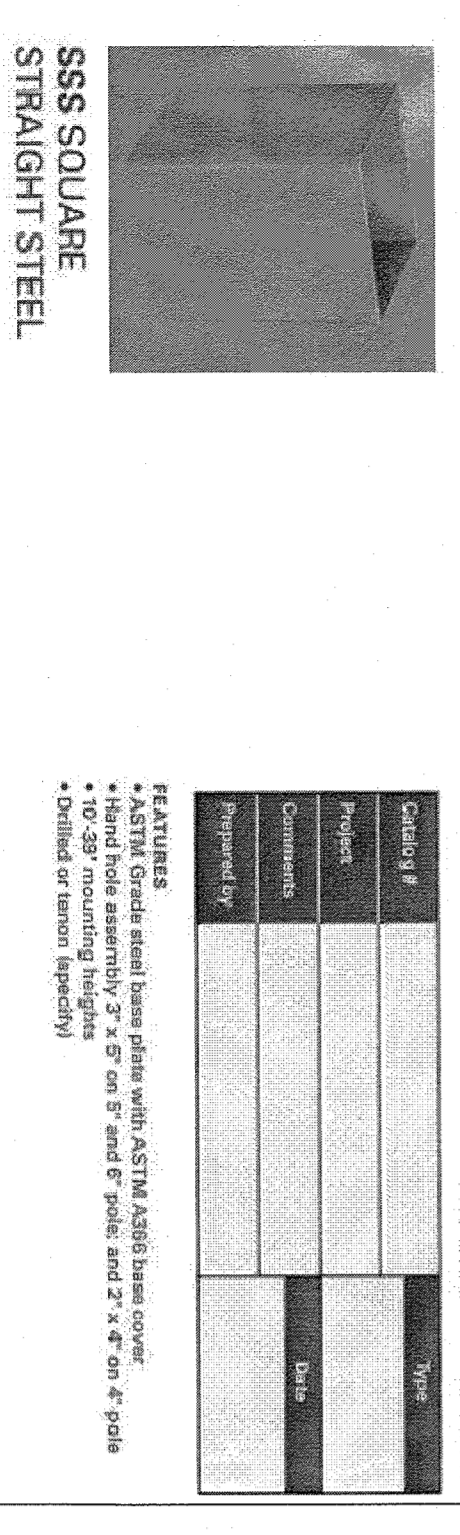

**Steel Poles**

FEATURES  
 • ASTM Grade steel base plate with ASTM A575 base coat  
 • 10' galvanized steel pole with 2" x 4" steel pipe  
 • 10' galvanized steel pole with 2" x 4" steel pipe  
 • 10' galvanized steel pole with 2" x 4" steel pipe

DESIGN CONSIDERATIONS

These drawings are prepared by Yost Design Landscape Architecture, Inc. based on information provided by the client. The client is responsible for providing accurate information. Yost Design Landscape Architecture, Inc. is not responsible for any errors or omissions in these drawings. The client is responsible for obtaining all necessary permits and approvals from the appropriate authorities. The client is responsible for providing all necessary information for the design of these drawings. The client is responsible for providing all necessary information for the design of these drawings.

1. EATON 4" SQUARE STEEL POLE: 12' MOUNTING HEIGHT  
 1.50" NOT TO SCALE

**PRODUCTION FEATURES**

Construction features are shown in accordance with the manufacturer's specifications. The manufacturer's specifications are available on the manufacturer's website. The manufacturer's specifications are available on the manufacturer's website. The manufacturer's specifications are available on the manufacturer's website.



**EXISTING BUILDING SPOT LIGHTS**

Existing building spot lights are shown in accordance with the manufacturer's specifications. The manufacturer's specifications are available on the manufacturer's website. The manufacturer's specifications are available on the manufacturer's website. The manufacturer's specifications are available on the manufacturer's website.

**EXISTING TOWN LIGHT POLES**

Existing town light poles are shown in accordance with the manufacturer's specifications. The manufacturer's specifications are available on the manufacturer's website. The manufacturer's specifications are available on the manufacturer's website. The manufacturer's specifications are available on the manufacturer's website.

- LIGHTING NOTES**
1. PROVIDE SWITCHING, TRANSFORMER LAYOUT AND WIRE SIZE FOR REVIEW BY LANDSCAPE ARCHITECT.
  2. SIZE LOW VOLTAGE WIRE BASED ON A MAX. ALLOWABLE VOLTAGE DROP OF 3%.
  3. TRANSFORMERS SIZED TO MAXIMUM CAPACITY OF LIGHT FIXTURE.
  4. DESIGN LOAD IS NOT TO EXCEED 80% OF TRANSFORMER CAPACITY.
  5. THE WORK IS TO COMPLY WITH ALL APPLICABLE CODES AND STANDARDS AND MEET ALL TESTING REQUIREMENTS.
  6. FINISH LOCATIONS AND WIRE LAYOUTS ARE DIAGRAMMATIC AND APPROXIMATE. BEFORE INSTALLATION, REVIEW ADJACENT CONTROLLERS IN AN ORDERLY FASHION TO ALLOW ACCESS AS NECESSARY.
  7. REFER TO THE PLAN FOR LIGHT FIXTURE LOCATION, UTILIZE CONDUIT (3) TIE TO THE (6) SWITCHING WHEEL POSSIBLE.
  8. BALANCE LOADS TO THE TRANSFORMERS, IDENTIFY CENTER OF LOAD.
  9. PROVIDE 120 VOLT POWER TO EACH REMOTE TRANSFORMER CONNECT TO SWITCH IN HOUSE PER DIRECTION AND ACCEPTANCE OF CLIENT.
  10. INSTALL FIXTURES PER MANUFACTURERS INSTRUCTIONS.

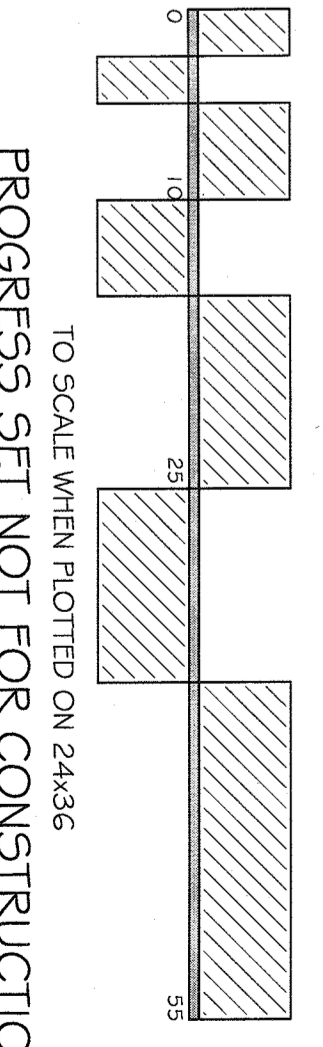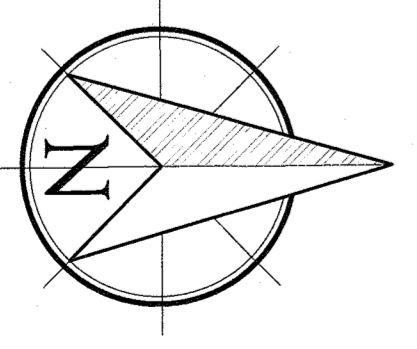


TO SCALE WHEN PLOTTED ON 24x36  
 PROGRESS SET NOT FOR CONSTRUCTION

SURFLOOR:

**DIONNES WAY**  
 PEARL RIVER, NY 10965

DATE: OCTOBER 15, 2018  
 DRAWN BY: ZJS  
 JOB NO.: 101118  
 SCALE: 1" = 10'  
 FILENAME: 2020\_0924  
 Dionnes Way


REVISIONS:

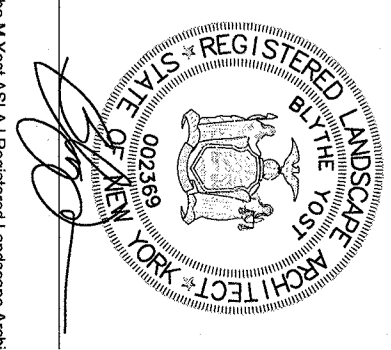

**PLANTING PLAN**








SHEET NO.

**L-701**

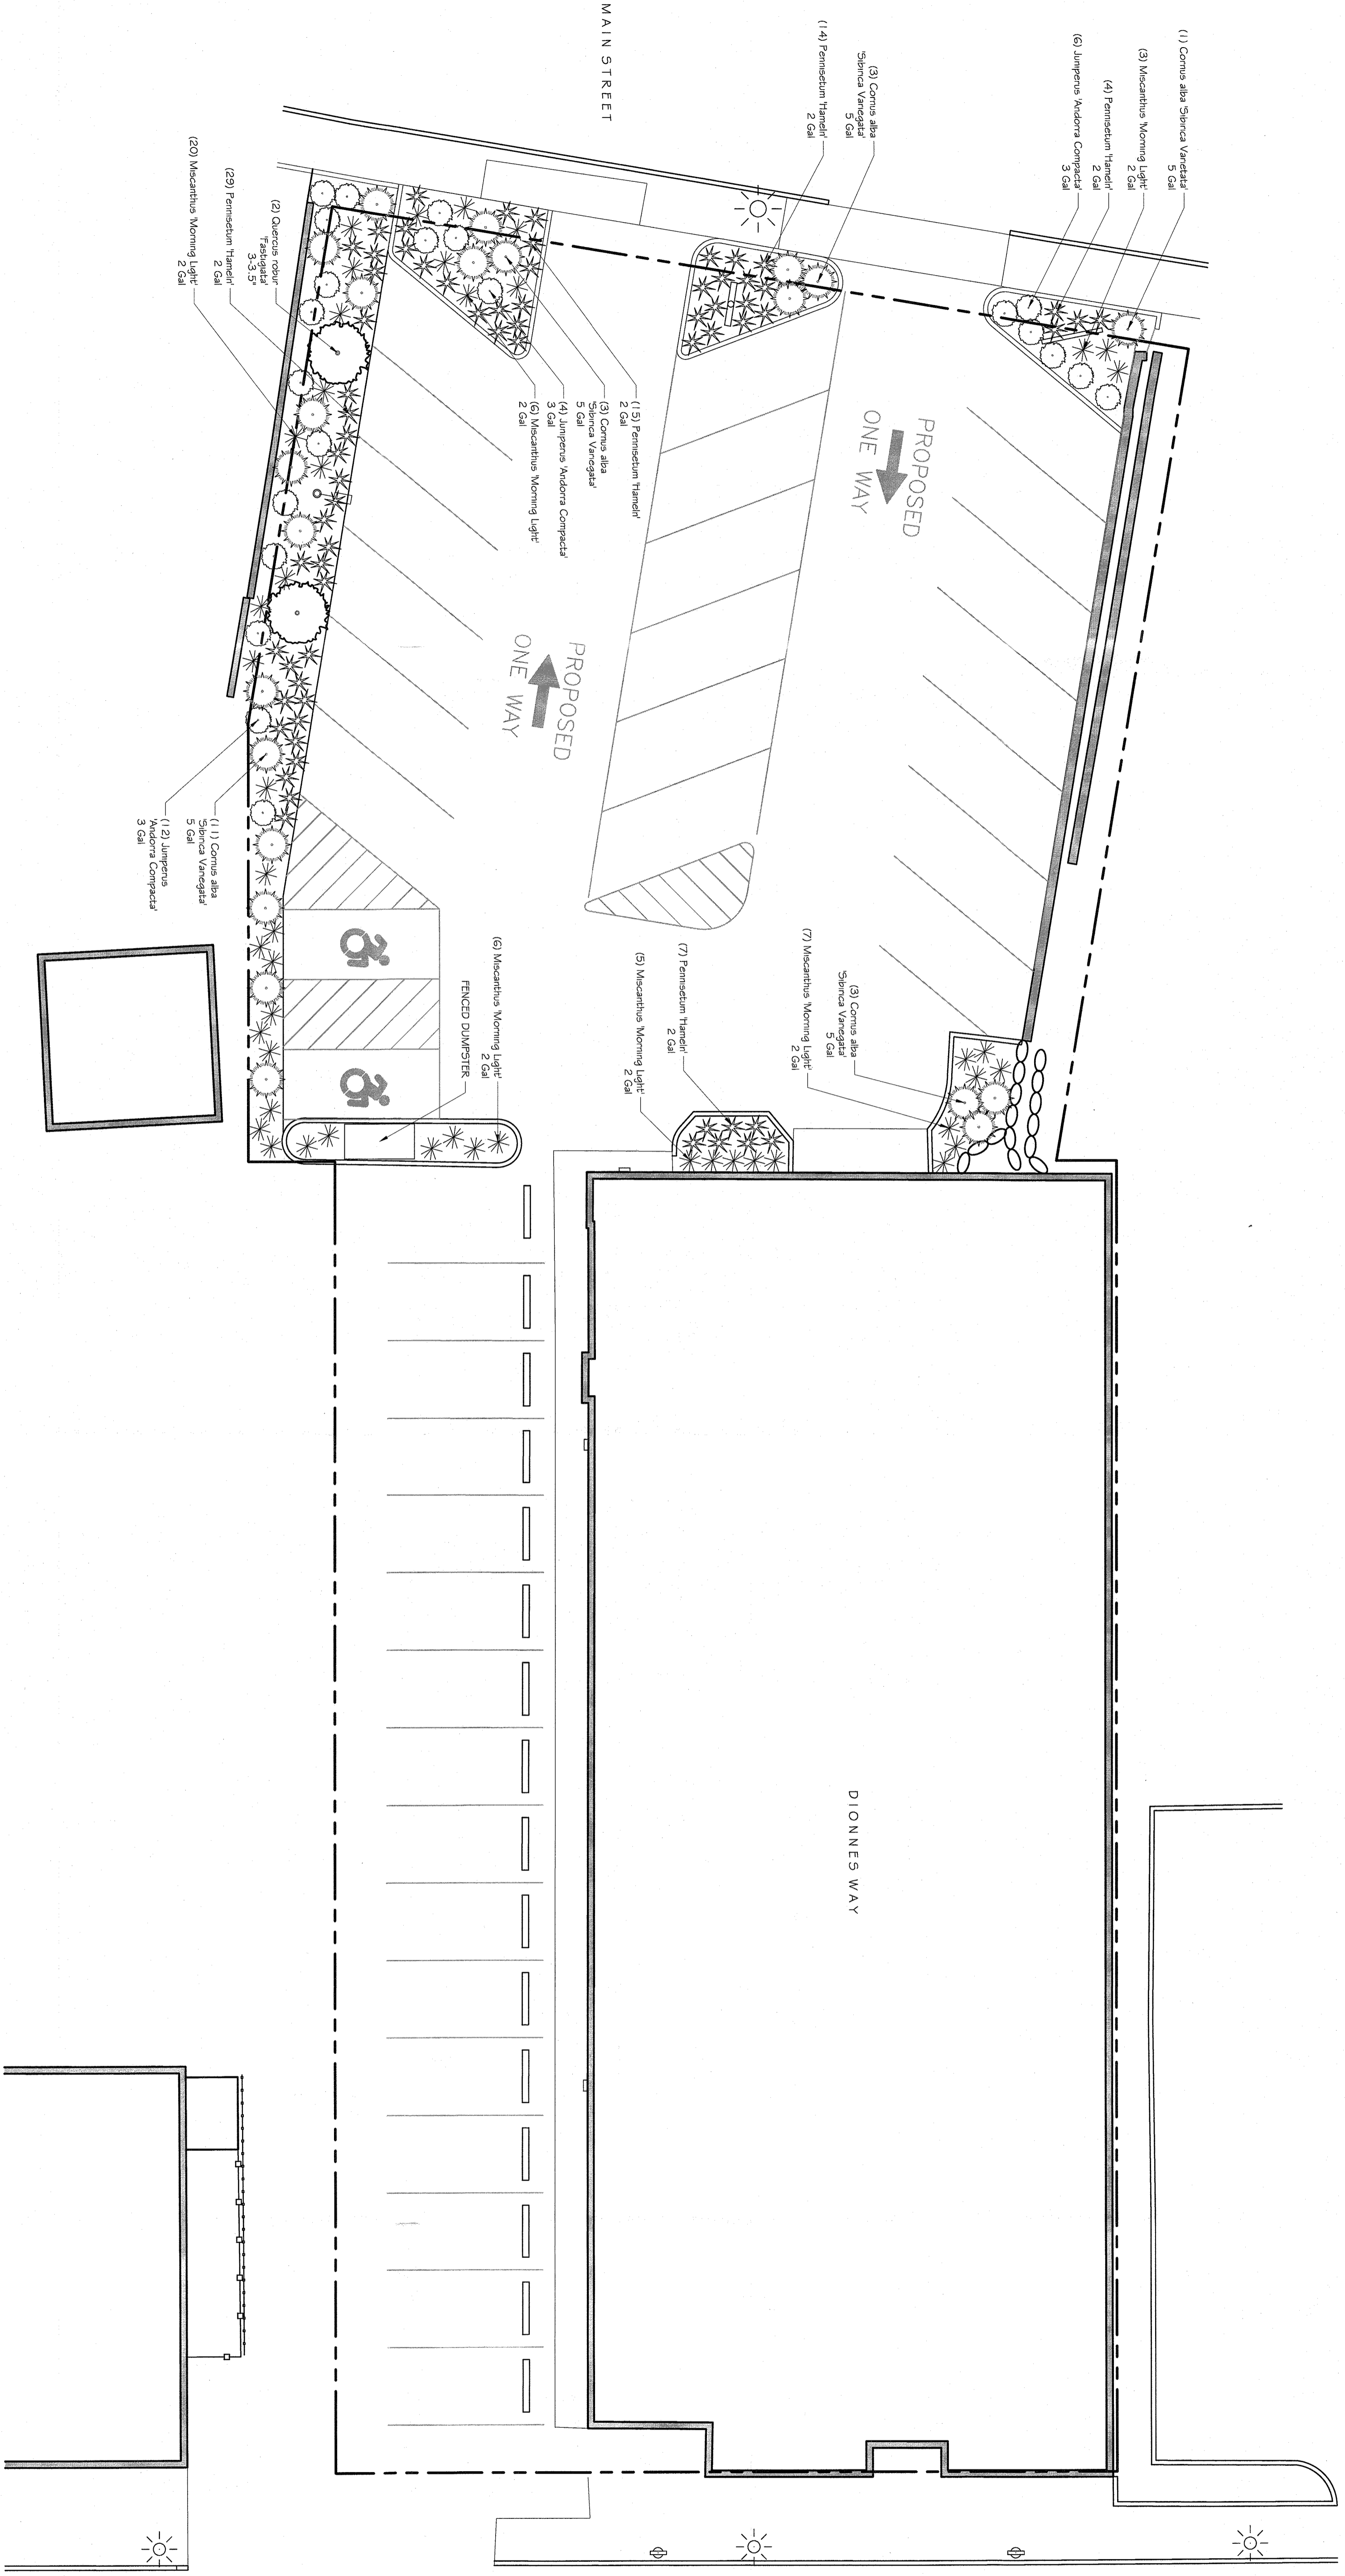

**PLANTING SCHEDULE**

QTY	BOTANICAL NAME	COMMON NAME	SIZE
2	Quercus robur 'Fastigiata'	Fragulate English Oak	3-3.5"
<b>SHRUBS</b>			
22	Cornus alba 'Sibirica Variegata'	Tataran Dogwood	5 Gallon
22	Juniperus horizontalis 'Andorra Compacta'	Andorra Compacta Juniper	3 Gallon
<b>GRASSES</b>			
47	Miscanthus sinensis 'Morning Light'	Morning Light Grass	2 Gallon
69	Pennisetum alopurourides 'Hammer'	Dwarf Fountain Grass	2 Gallon

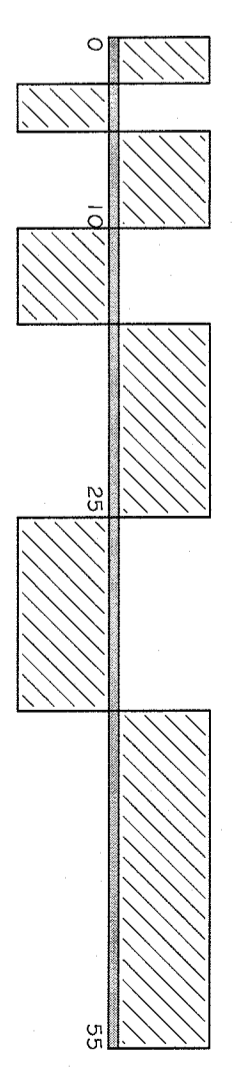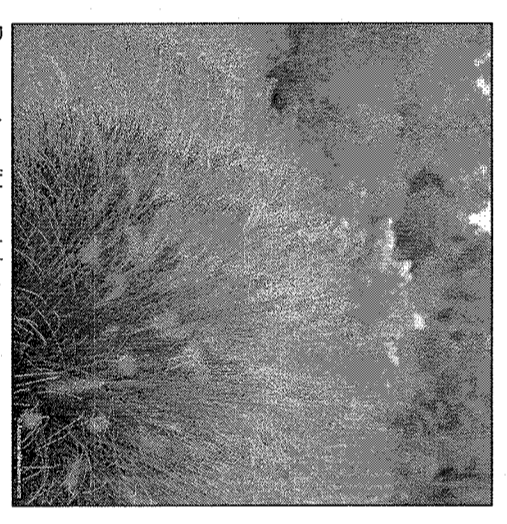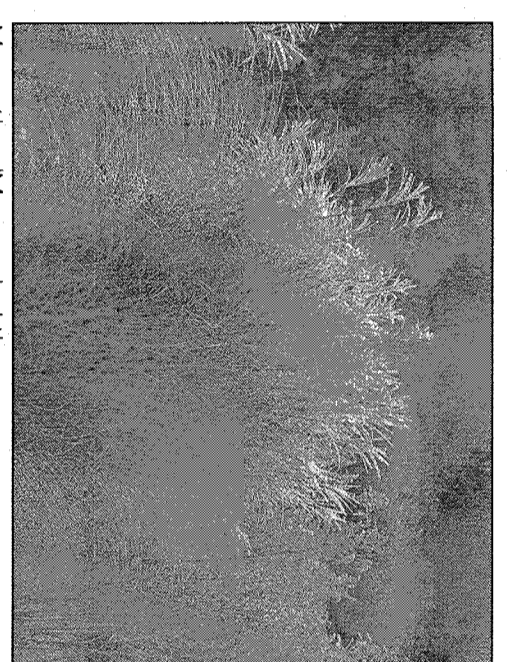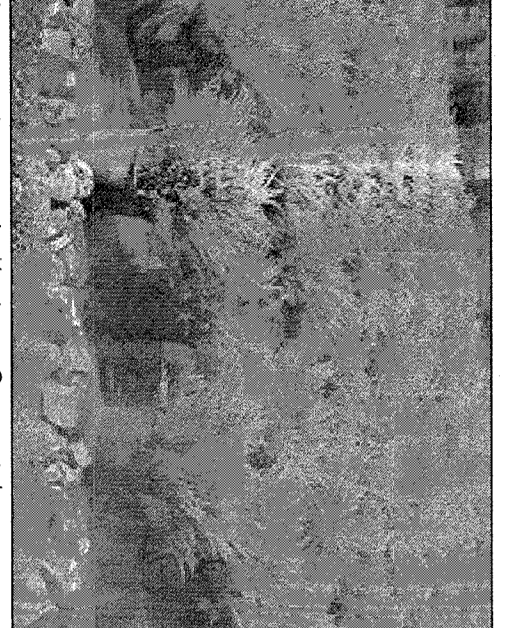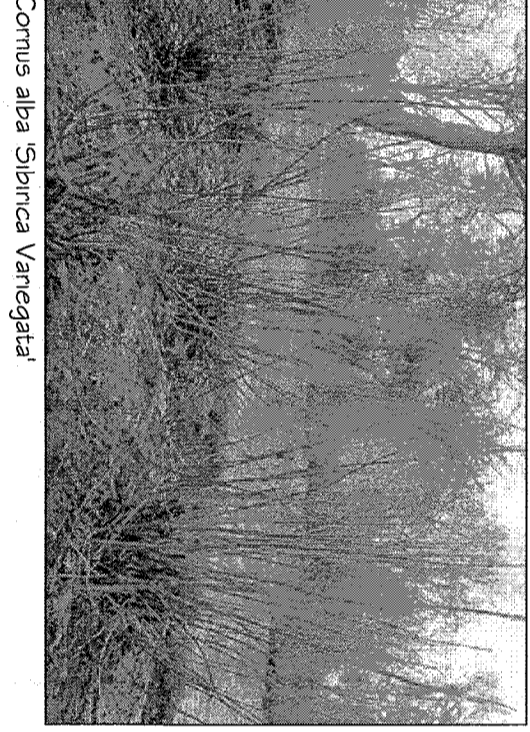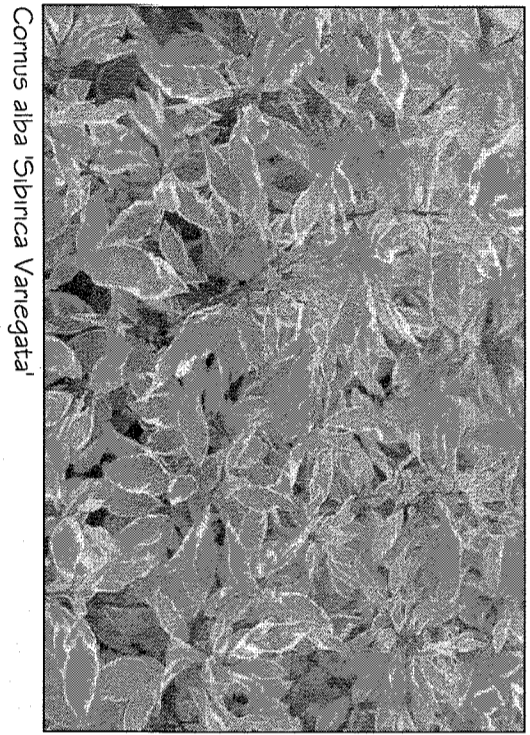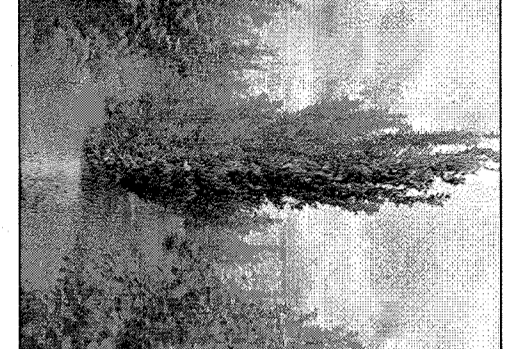

TO SCALE WHEN PLOTTED ON 24x36  
 PROGRESS SET NOT FOR CONSTRUCTION